


3 PLY BUILT UP ROOF ON
RIGID INSULATION ON
ASPH IMPREG 15# ROOFING FELT
2x6 WOOD T & G SHEATHING

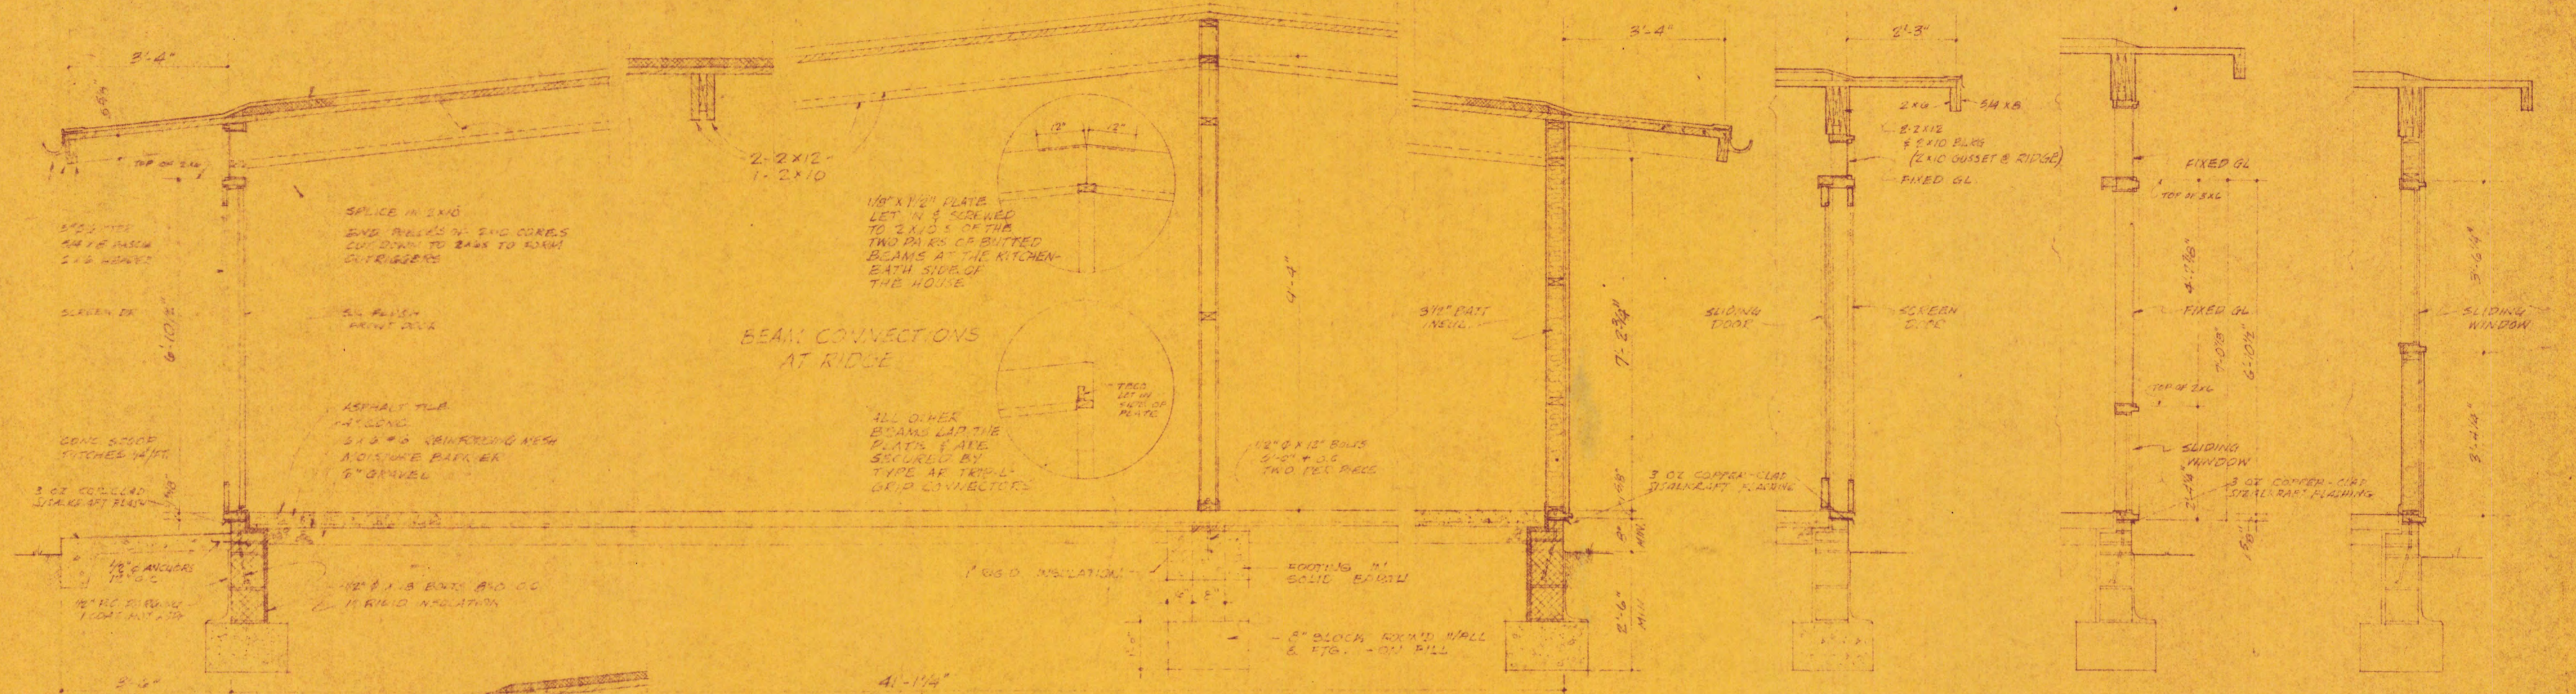

END WALL AT FRONT DOOR

BEARING PARTITION


END WALL AT FRAME

SLIDING DOOR

SIDE WALL AT GLASS

SIDE WALL AT WINDOW

HOUSE TYPE A STORAGE SIMILAR

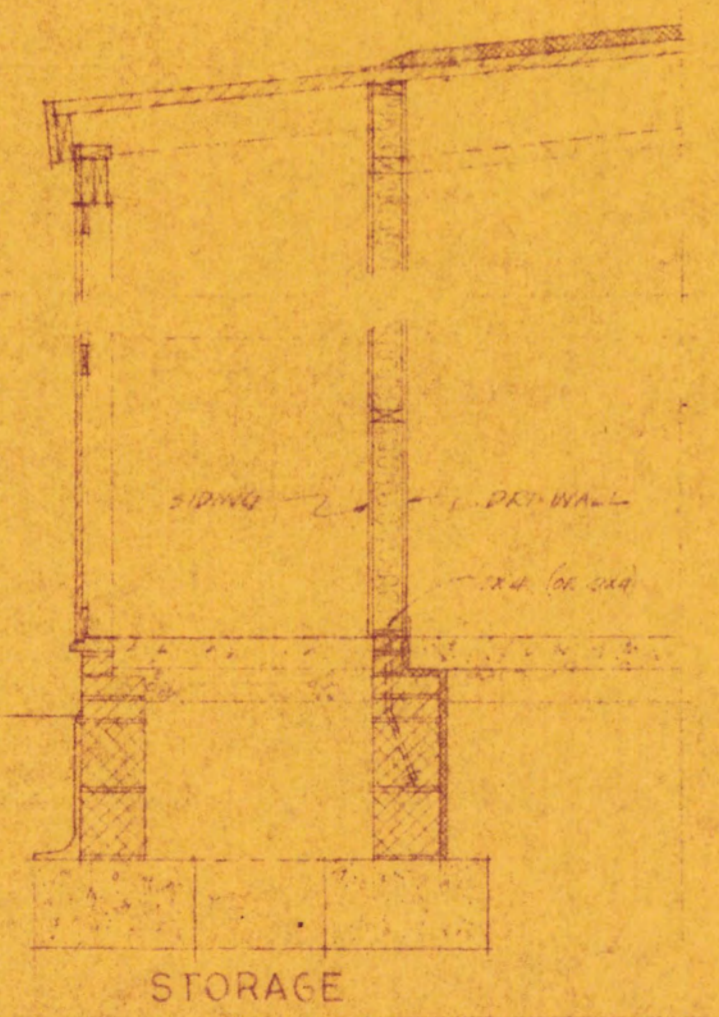


SECTION
ALTERNATE ROOF HOUSE

HOUSE TYPE B

REVISIONS:
6/8/52 CONT. NUOLS EXPOSED SILL
8/25/52 PARKING AT FOOTINGS
10/19/52 CONC. STOOP ANCHORED TO WALL
UAP R. BARRIER
FLASHING

PINE SPRING - LURIA BROS., BUILDERS
LEE BLVD - LEE HIGHWAY, FAIRFAX COUNTY, VA.
SECTIONS ALTERNATE ROOF HOUSE
DATE 5/13/52 DRAWN BY DC, FLM CHECKED BY
FRANCIS D. LETHBRIDGE ARCHITECTS
THREE DUPONT CIRCLE WASHINGTON & D. C. HOBART 3315

52-02
B-3
OF

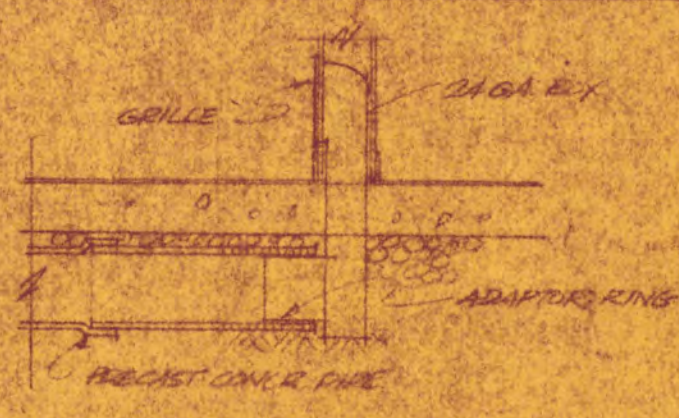

NOTE: VELOCITY AT THROAT NOT TO EXCEED 100 FT/MIN. MAX. 300 FT/MIN. AT GRILLE.

SECTION AT GRILLE

HEATING UNIT

GAS FIRED - EQUAL TO "MORCIEF" LC-95-E 70,000 BTU
AGA RATING AT DISCHARGE OUTLET - COUNTERFLOW UNIT.

DUCTWORK

SHALL BE PRECAST CONCRETE PIPE WITH CEMENTED JOINTS
SO THAT BELL ENDS POINT IN DIRECTION OF FLOW. SHEET METAL
BOX OF GRILLE SHALL BE AT LEAST 24 GA. (30 ALUM. 26 GA. HEAVY)


REGISTERS

SHALL BE OF HEAVY GAUGE AND HAVE A CLEAR OPENING OF AT
LEAST 60% OF FACE AREA, AND HAVE AT LEAST ONE 5/8\"/>


CONTROLS

FURNACE FAN FROM ROOM THERMOSTAT WHEN PREDETERMINED
BURNER SETTING IS REACHED. SHUT OFF WHEN ROOM THERMO
STAT SETTING IS REACHED. HIGH TEMPERATURE SHUT OFF OF
BURNERS FROM DUAL CONTROL IN BURNER OR FLENDI.

LIVING RM.	20,000 BTU/HR
DINING RM.	8,500
KITCHEN	5,500
BEDRM # 1	6,500
BEDRM # 2	6,000
BEDRM # 3	4,000
BATH	4,000
TOTAL	69,000 BTU/HR

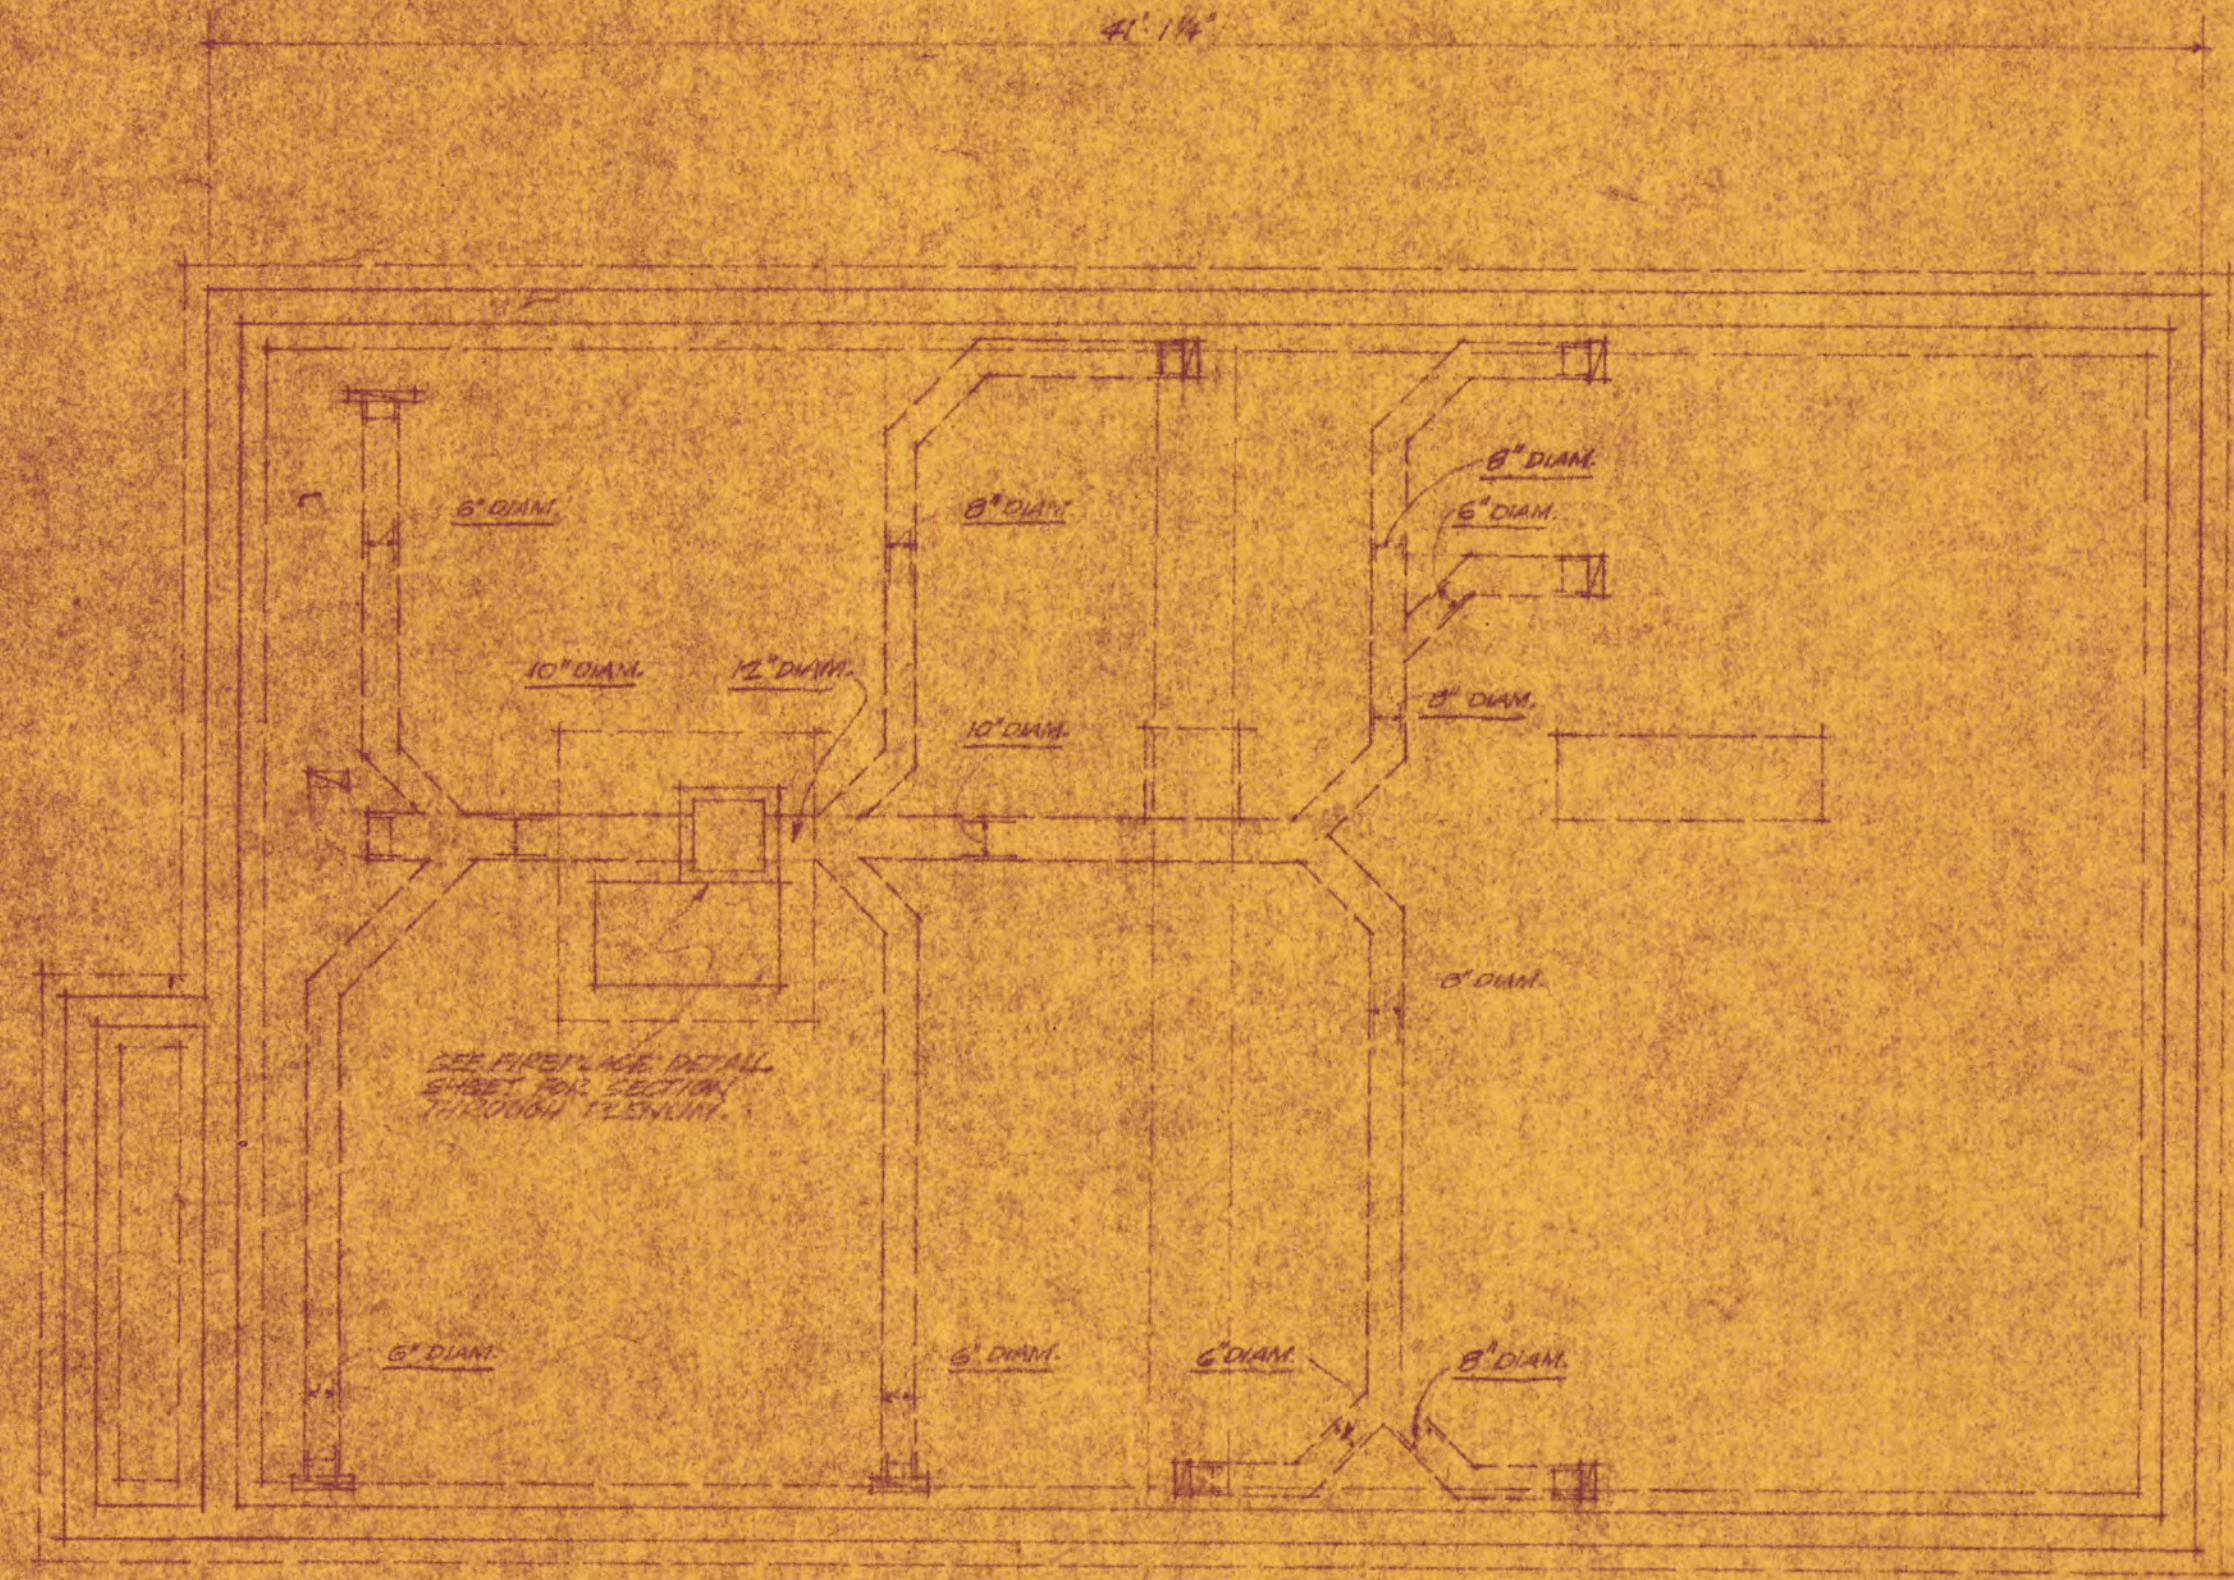

FOUNDATION PLAN

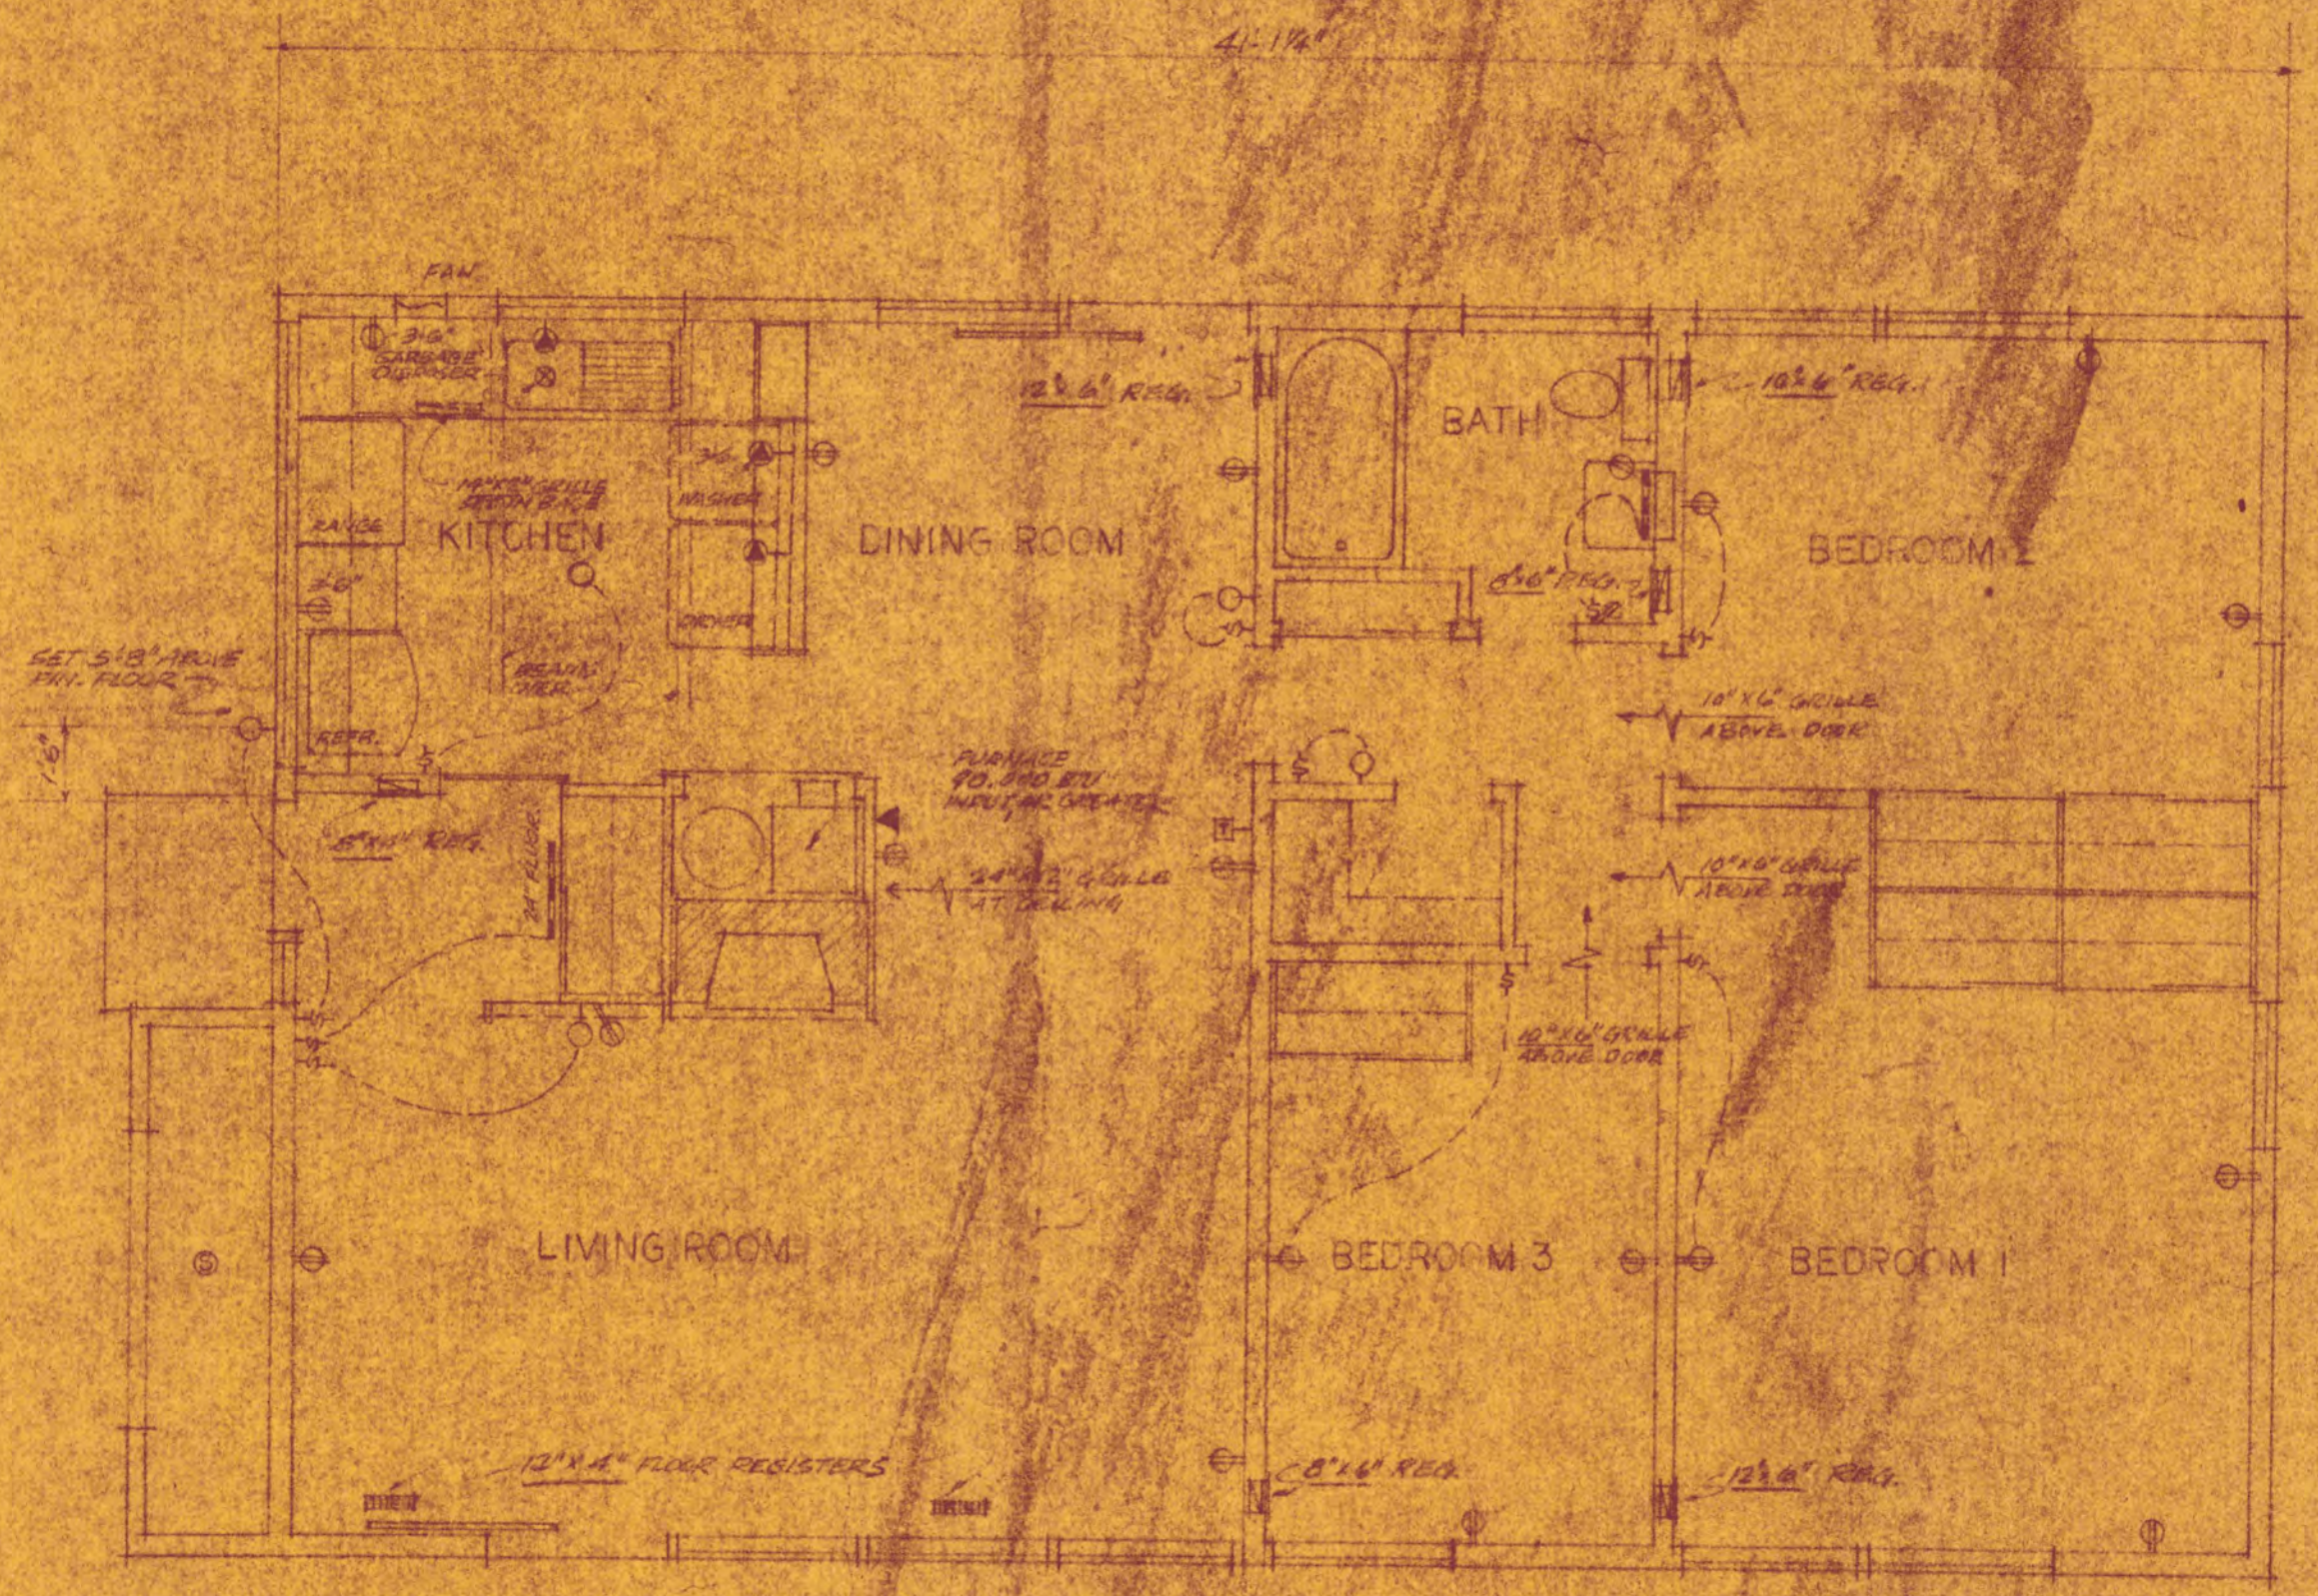


FLOOR PLAN

- NOTE: 1. ALL DUPLEX OUTLETS 14\"/>
 - RETURNS TO BE 40% VOLUME OF SUPPLY
 - SLAB EDGE INSULATION TO BE RIGID FIBER GLASS

HOUSE TYPES A & B


REVISIONS
10/9/51 NOTES 2 & 3 ABOVE (S.H.A.)

PINE SPRING - LURIA BROS. BUILDERS		JOB 52-02
LEE BLVD. - LEE HIGHWAY - FAIRFAX COUNTY VA.		
HEATING & ELECTRICAL PLANS		SH. M-I
SCALE: 1/4" = 1'-0"	DATE: 5/13/52	
KEYES, SMITH & SATTERLEE - ARCHITECTS		OF
FRANCIS D. LETHERIDGE - ASSOCIATE		
THREE DUPONT CIRCLE - WASHINGTON, D. C. - ROBERT 3918		

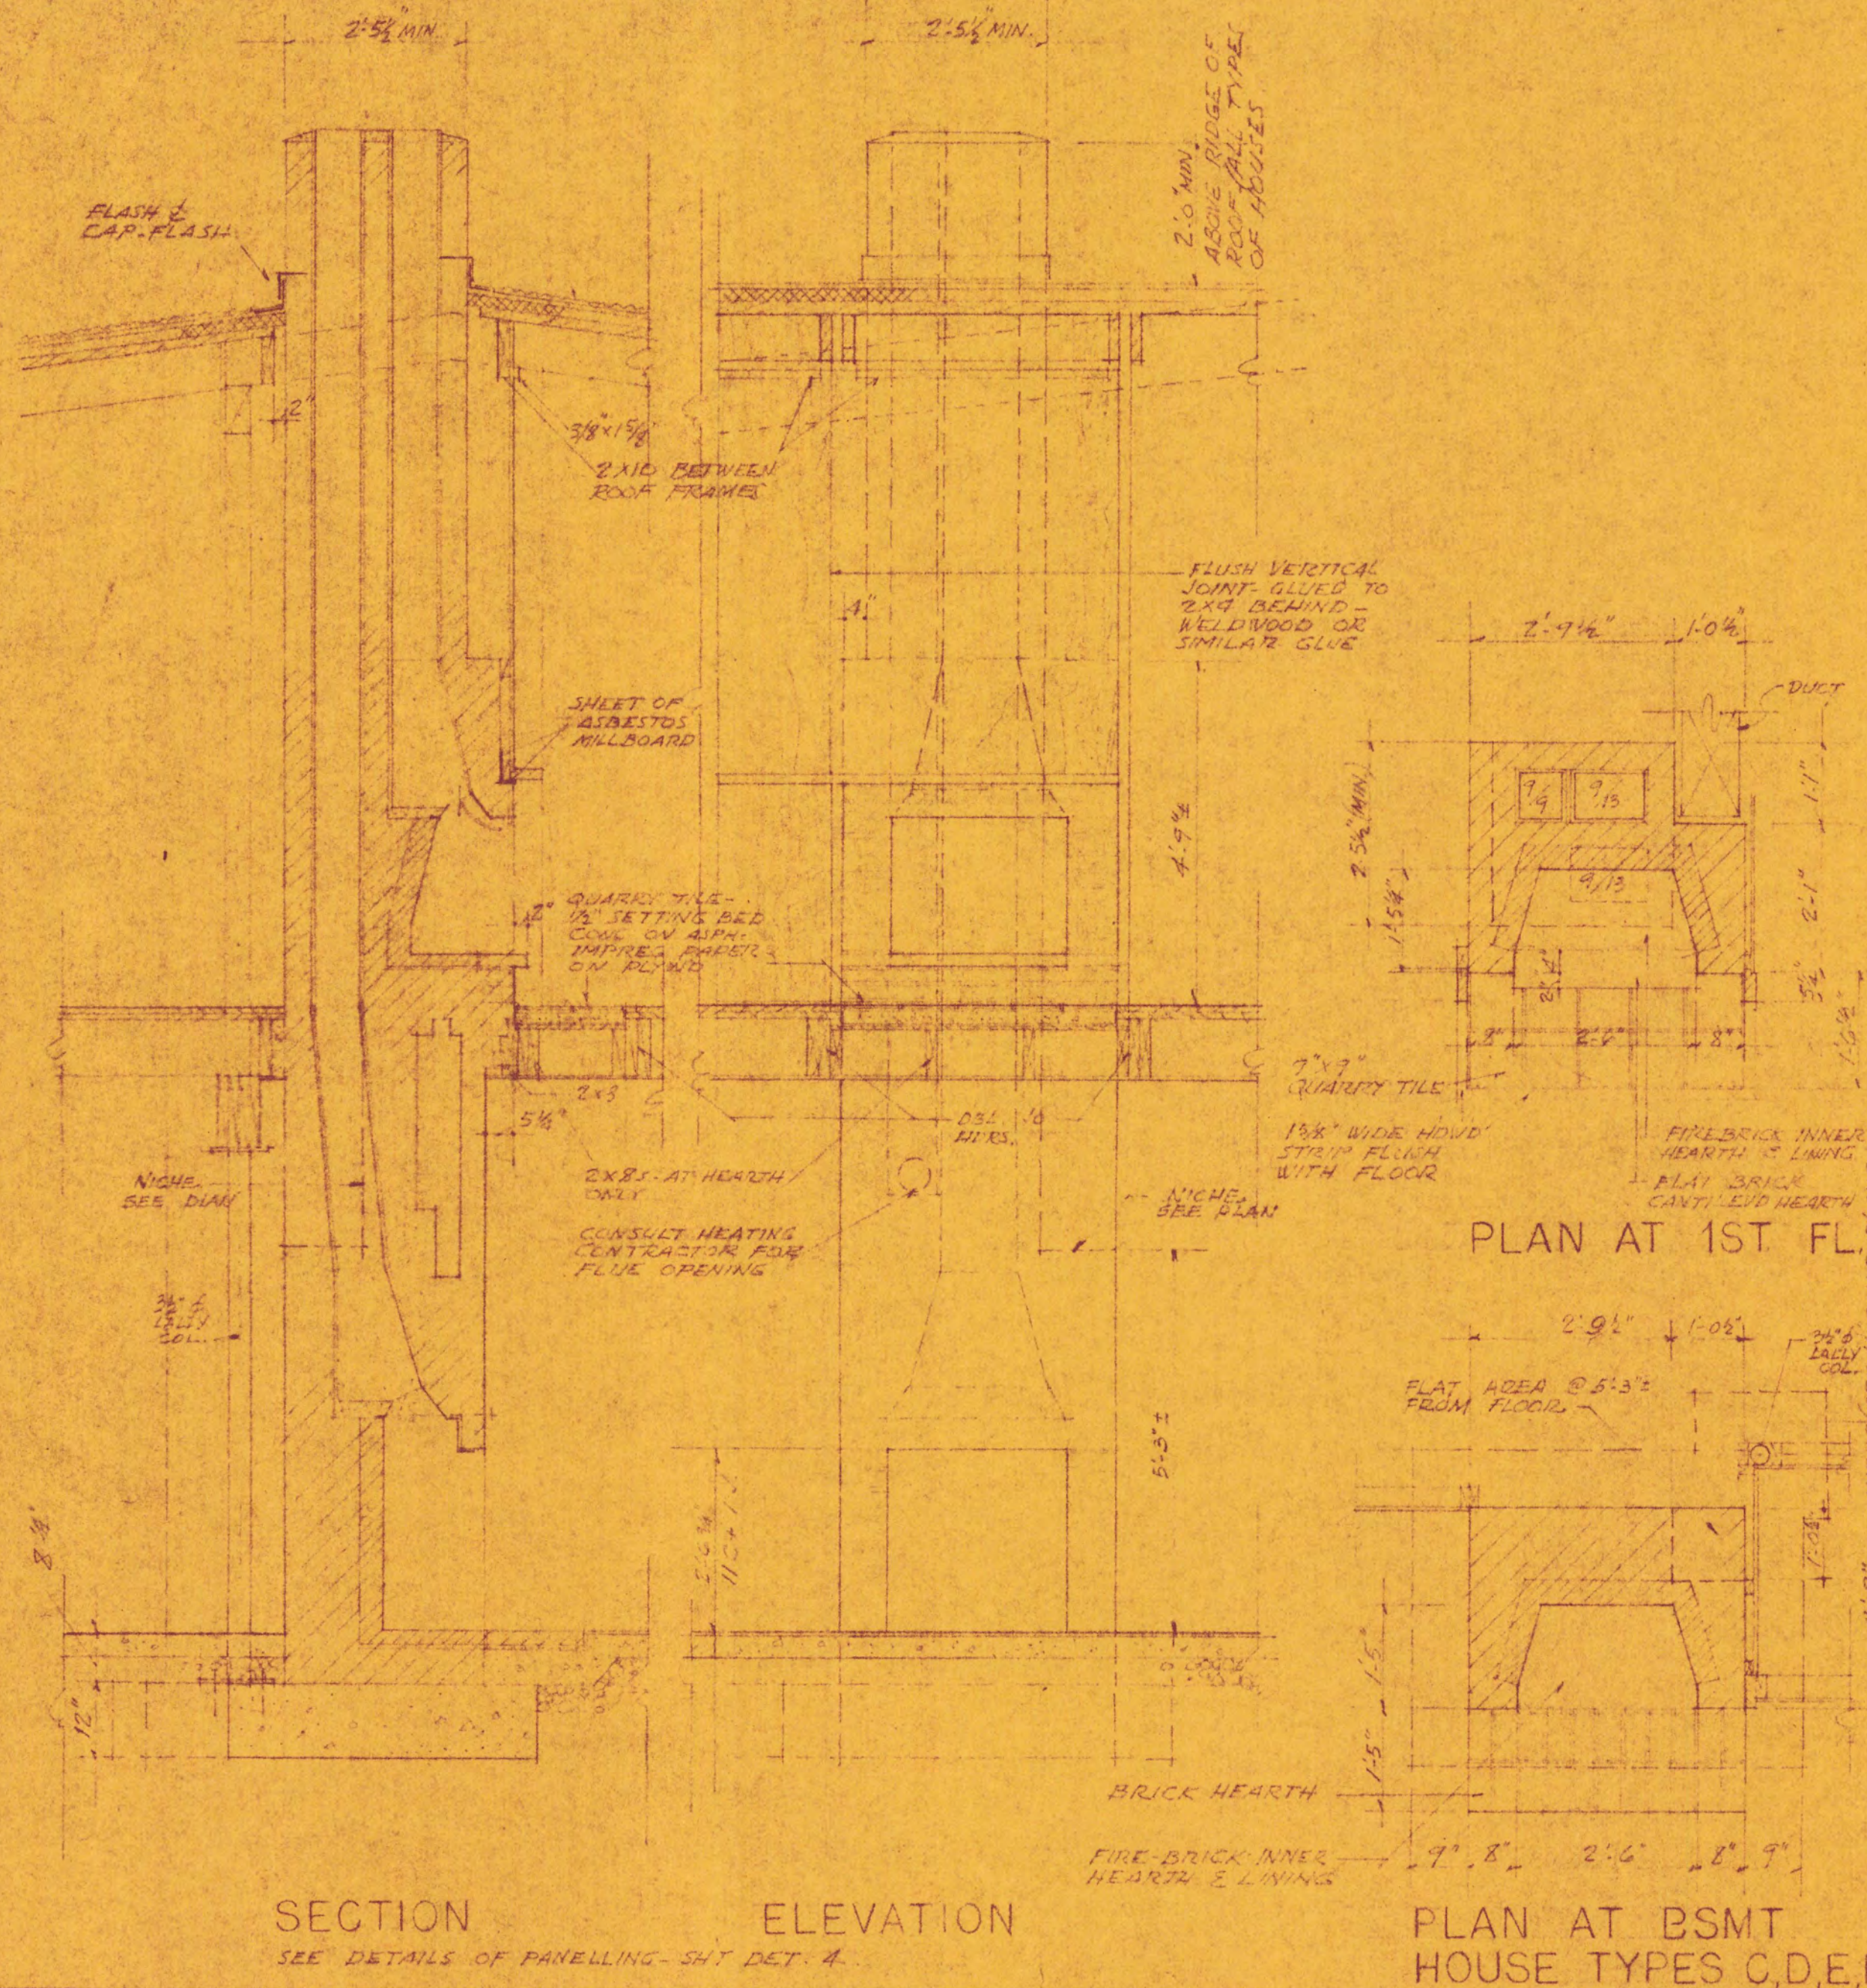

SECTION
SEE DETAILS OF PANELLING - SHIT DET. A

ELEVATION

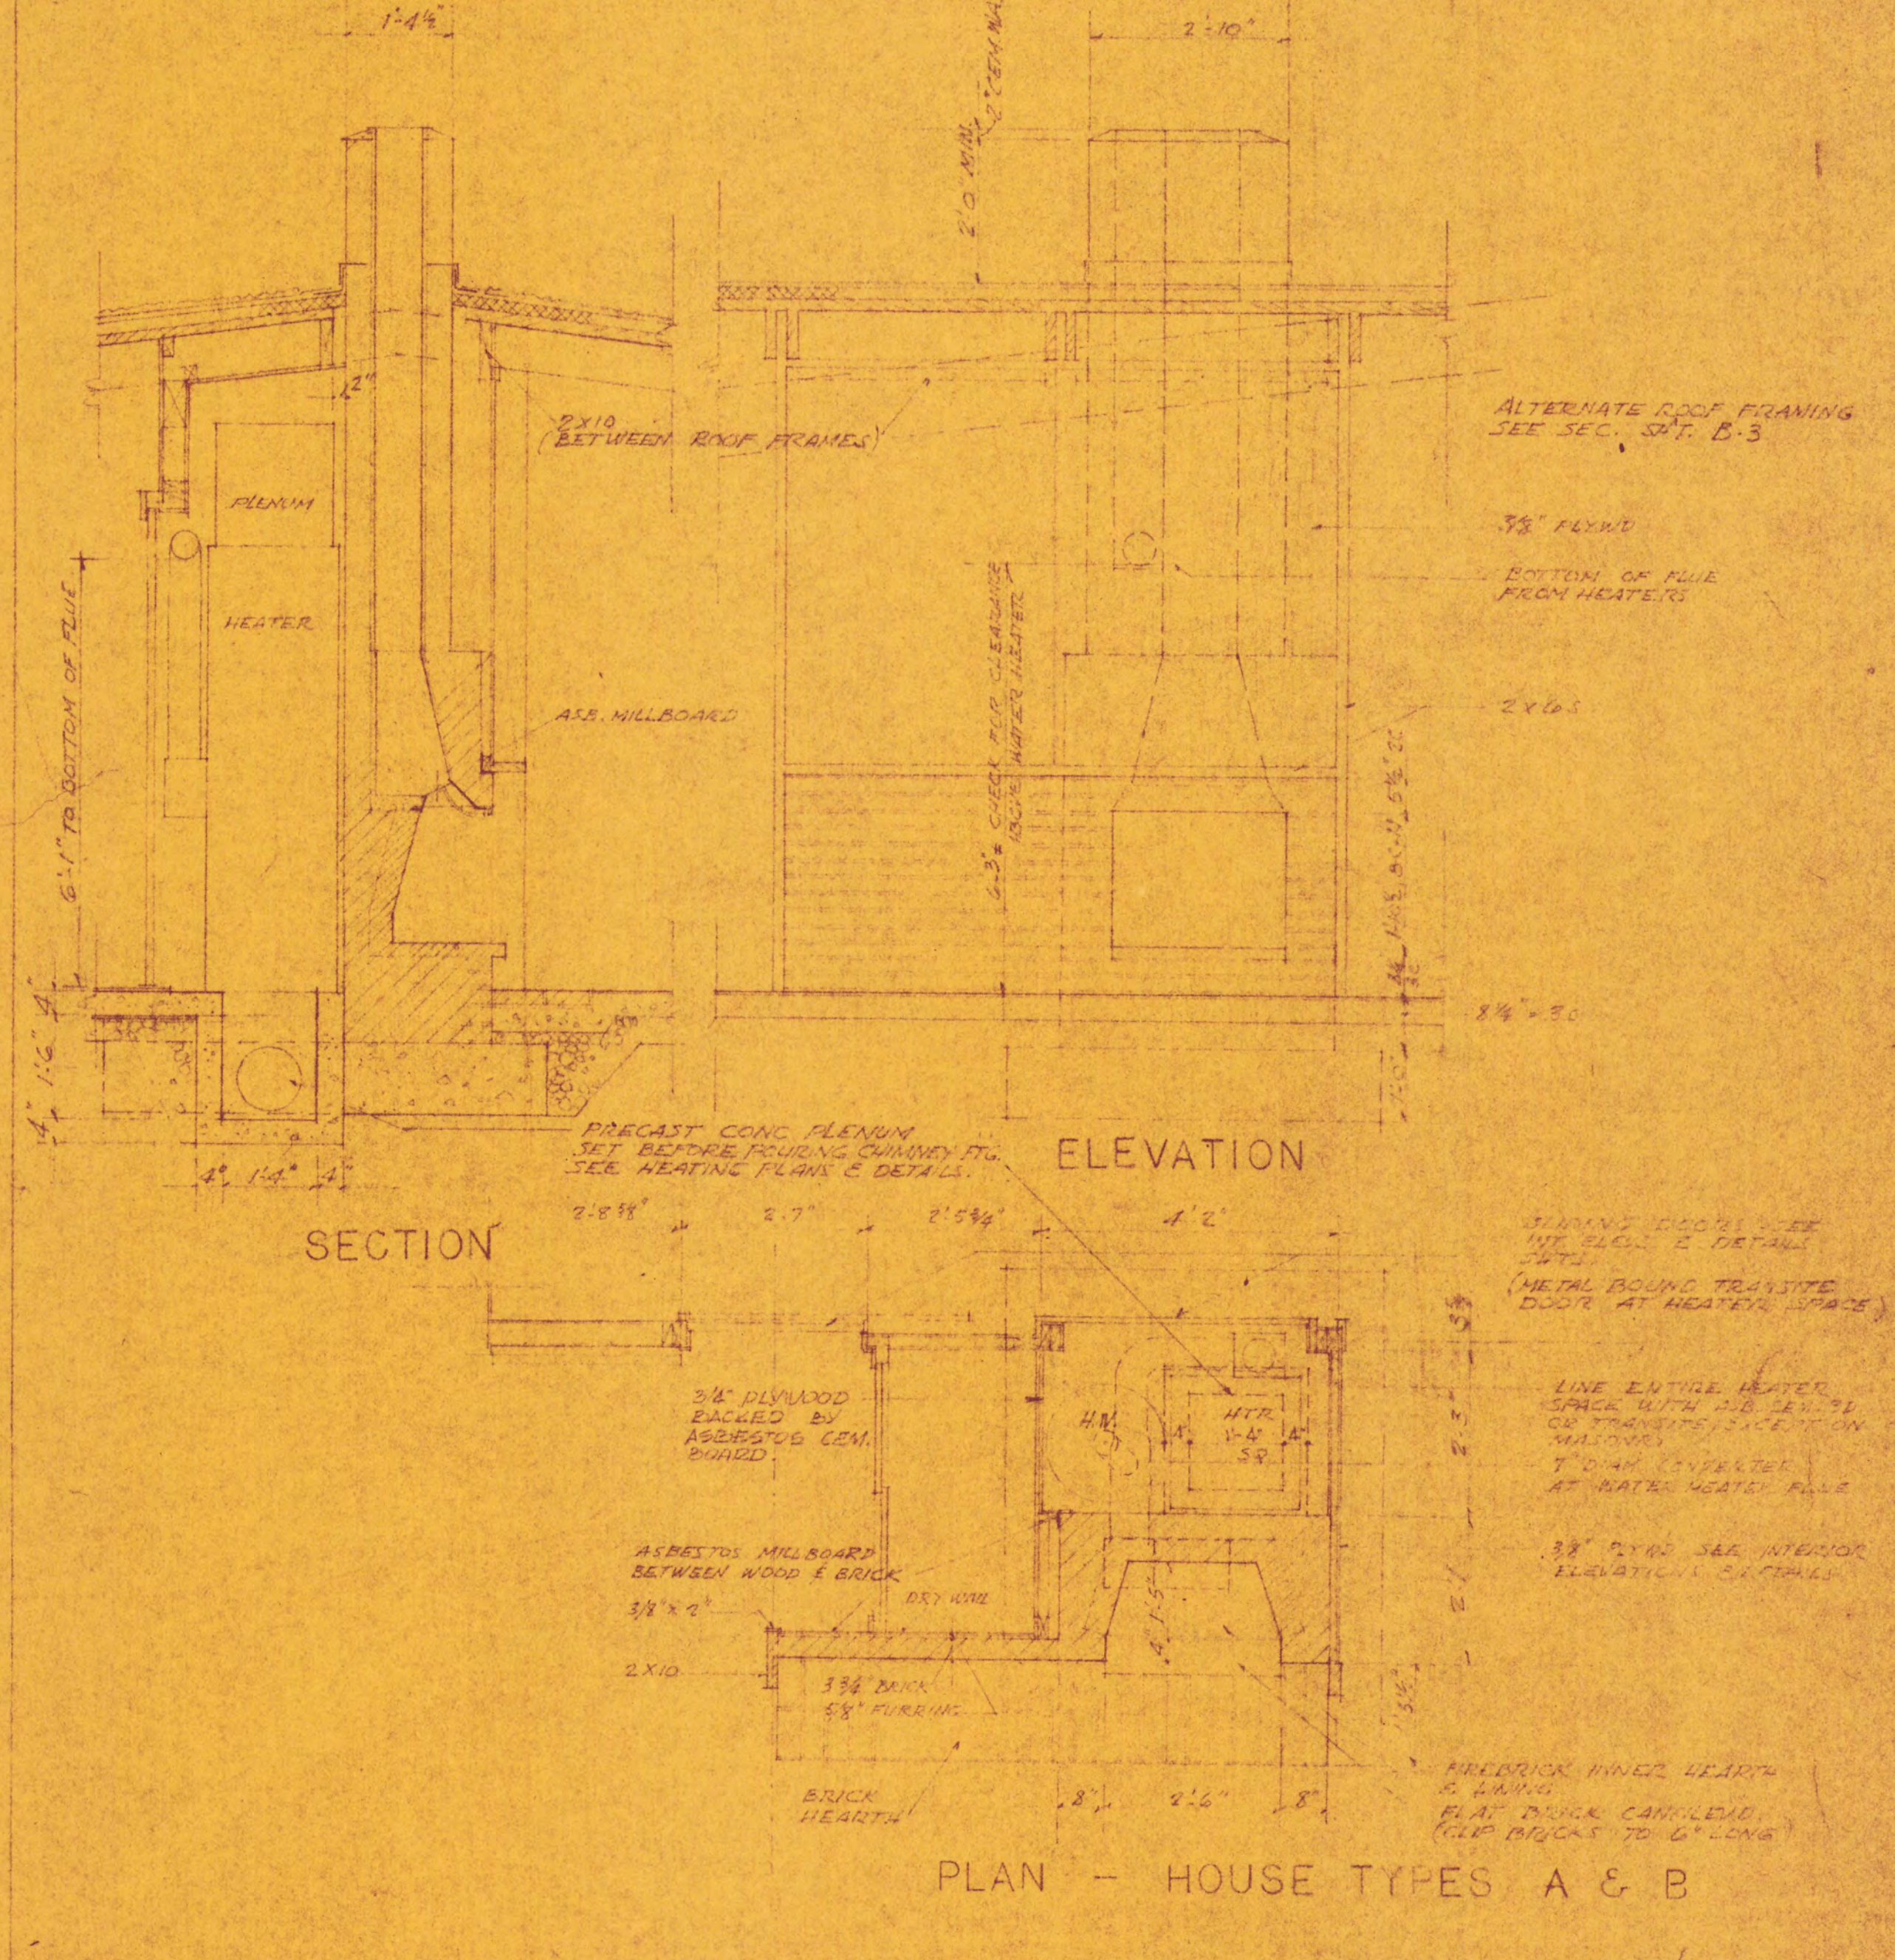

SECTION


ELEVATION

PLAN - HOUSE TYPES A & B


REVISIONS
 10/9/52 BRICK HEARTH ADDED
 ASBESTOS BETWEEN WOOD
 WOOD & CHIMNEY
 BRICK PANEL ADJACENT
 TO FIREPLACE ADDED
 (HOUSE TYPES A & B)
 BASEMENT FIREPLACE
 (HOUSE TYPES C, D, E, F)
 FLEYScreens OMITTED

PINE SPRING - LURIA BROS - BUILDERS		JOB	52-02
LEE BLVD. - LEE HIGHWAY - FAIRFAX COUNTY, VA		SH.	STR-4
CHIMNEY DETAILS			
SCALE: 1/2" = 1'-0"		DATE: 5/23/52	DRAWN BY: M. G. CHECKED BY:
KEYES, SMITH & SATTERLEE - ARCHITECTS		THREE DUPONT CIRCLE - WASHINGTON 6, D. C. - HOBART 9615	


29

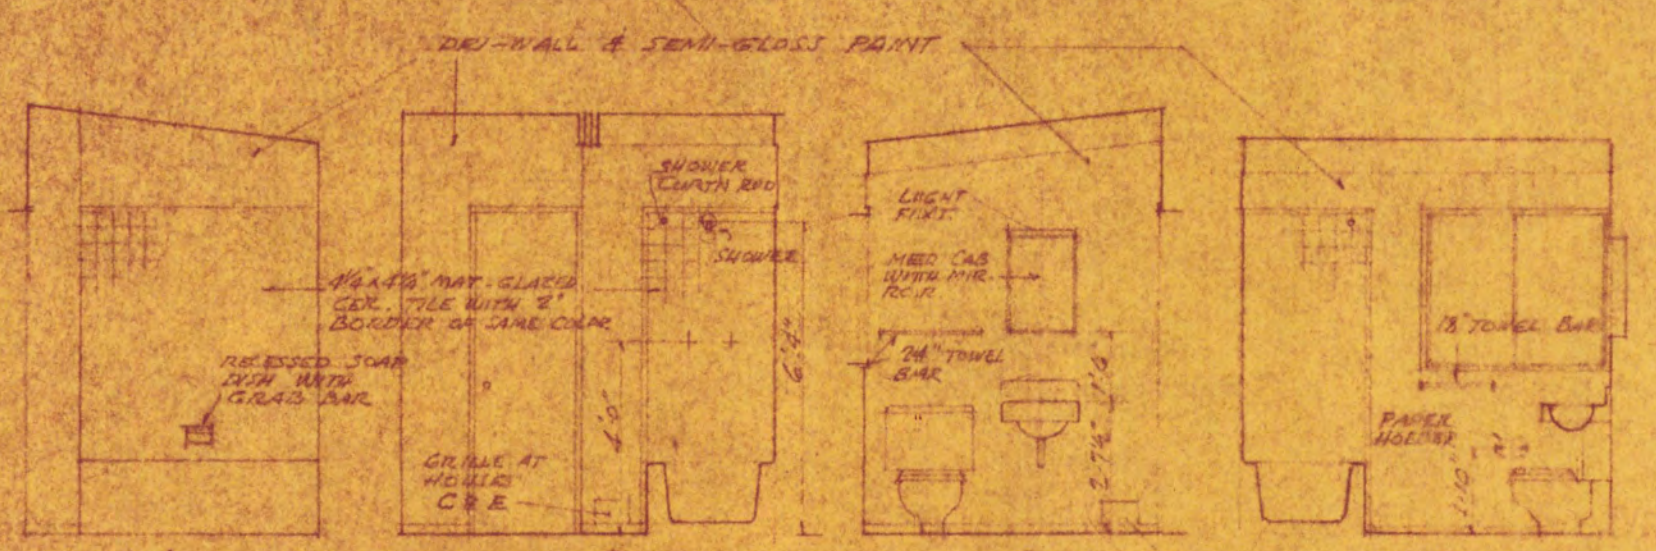


BATHROOM - HOUSE TYPES A, C, E

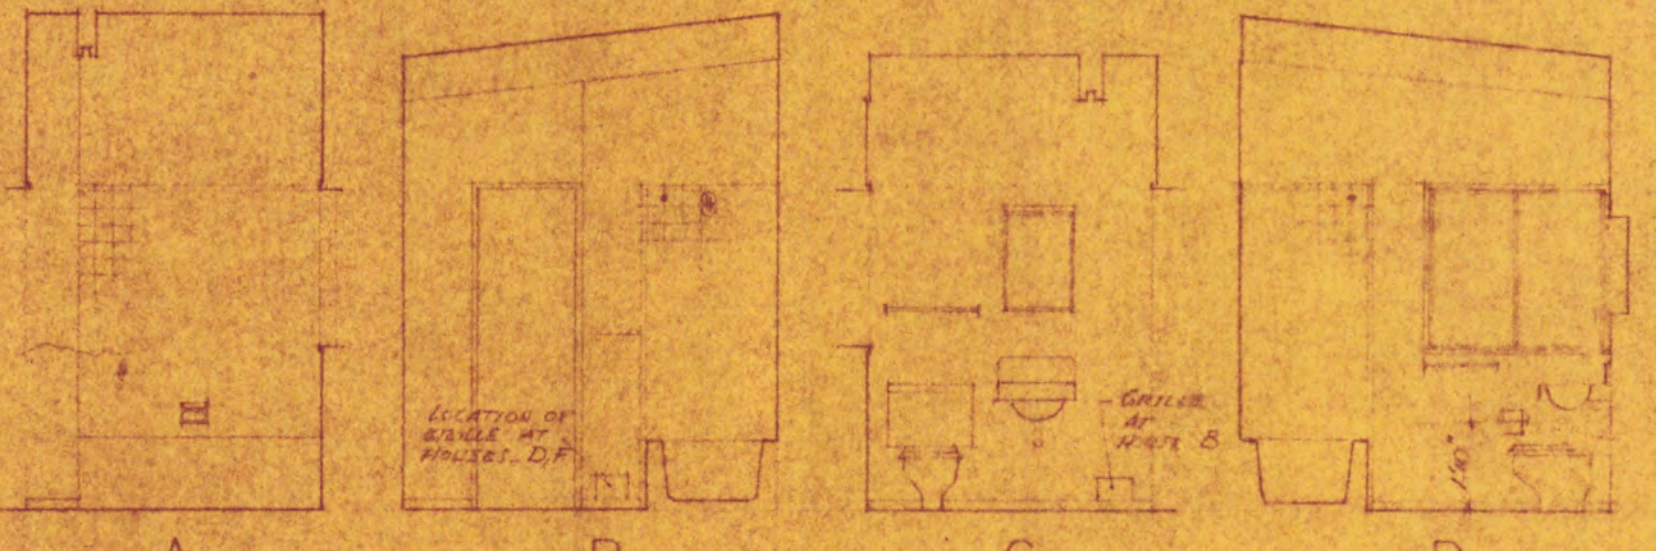


BATHROOM - HOUSE TYPES B, D, F

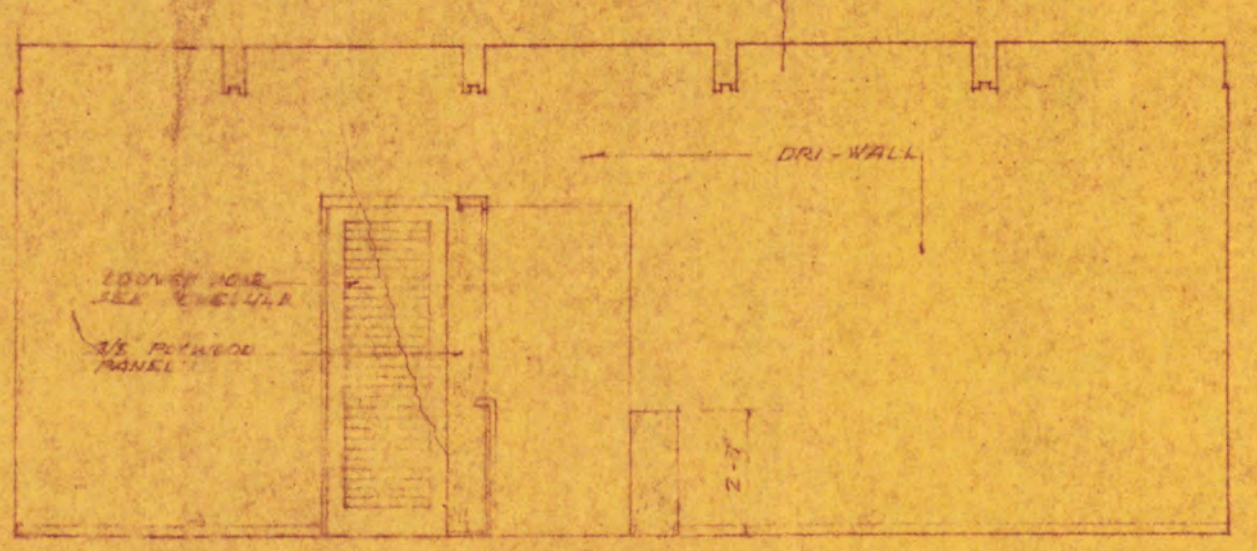


DINING RM - HOUSE TYPES D & F

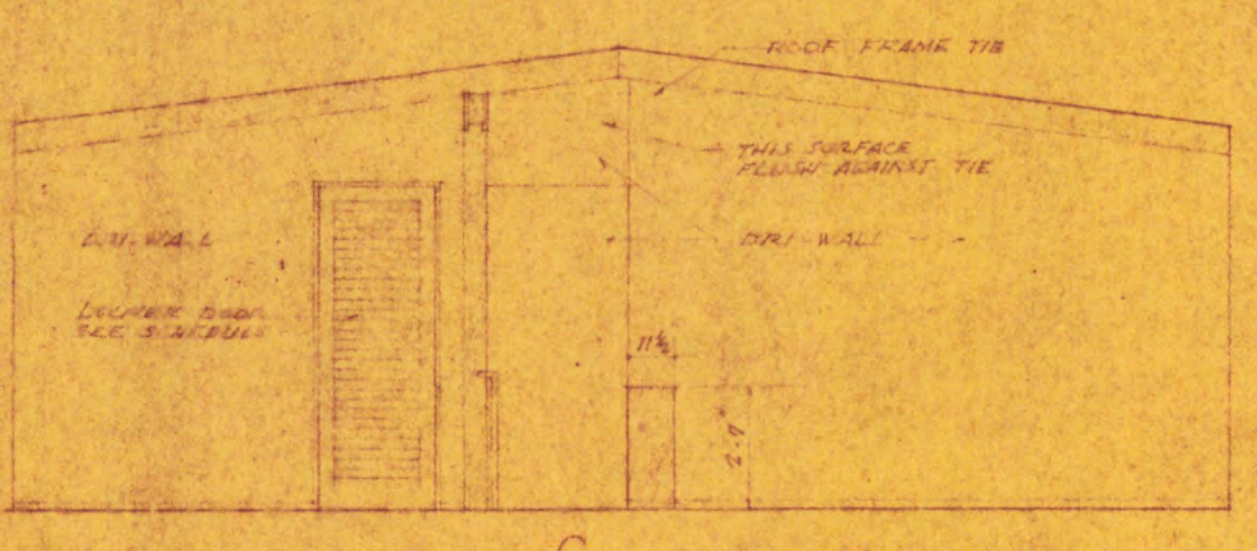


DINING RM - HOUSE TYPES C & E

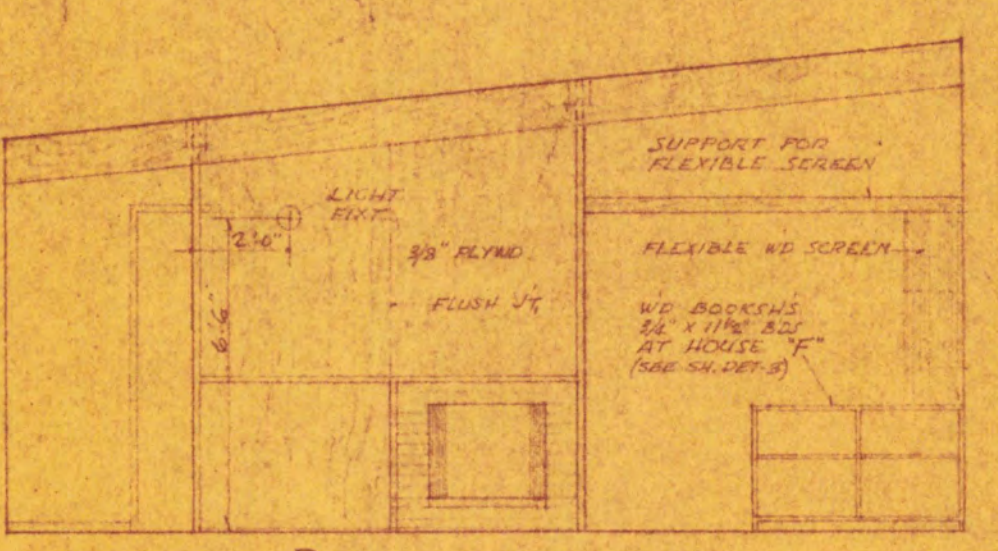


LIVING RM - HOUSE TYPES B & F

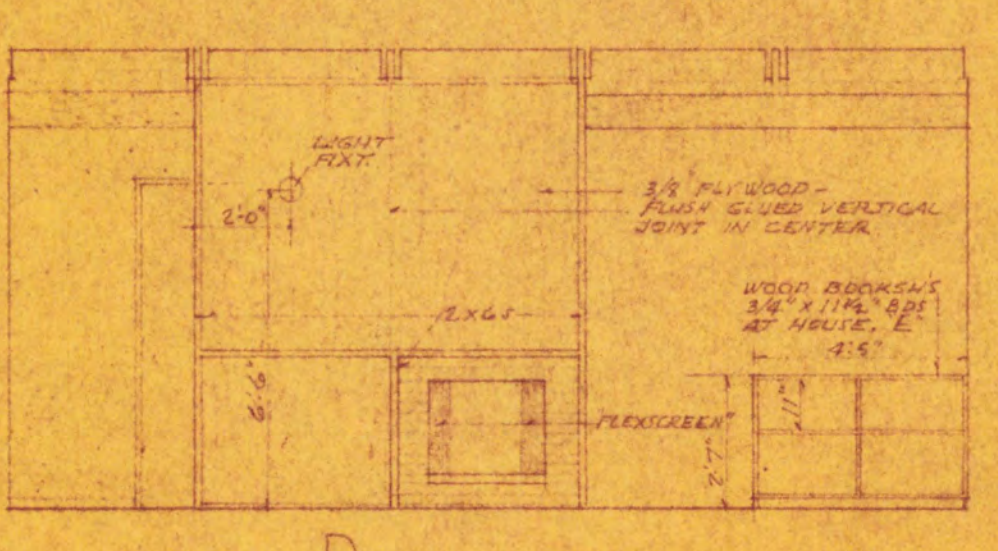


LIVING RM - TYPES A & E

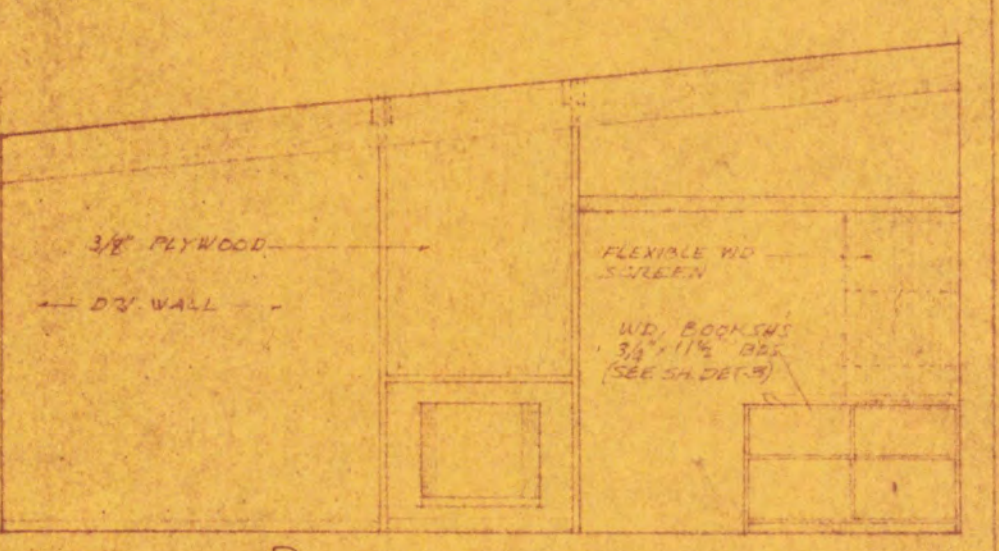


LIVING ROOM - HOUSE TYPE D

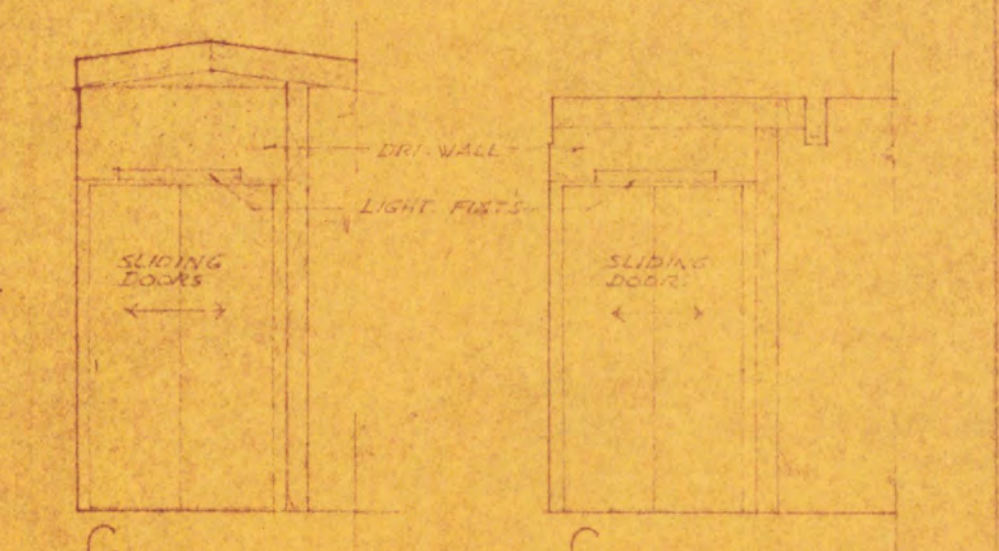


ENTRY - TYPES A & E - TYPES B & F

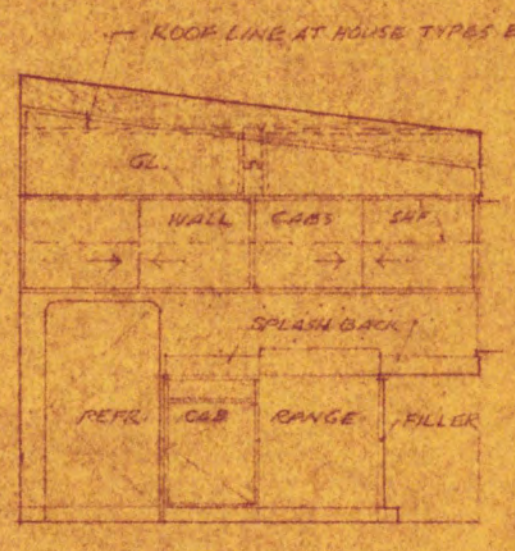


KITCHEN HOUSE TYPES A, C, E

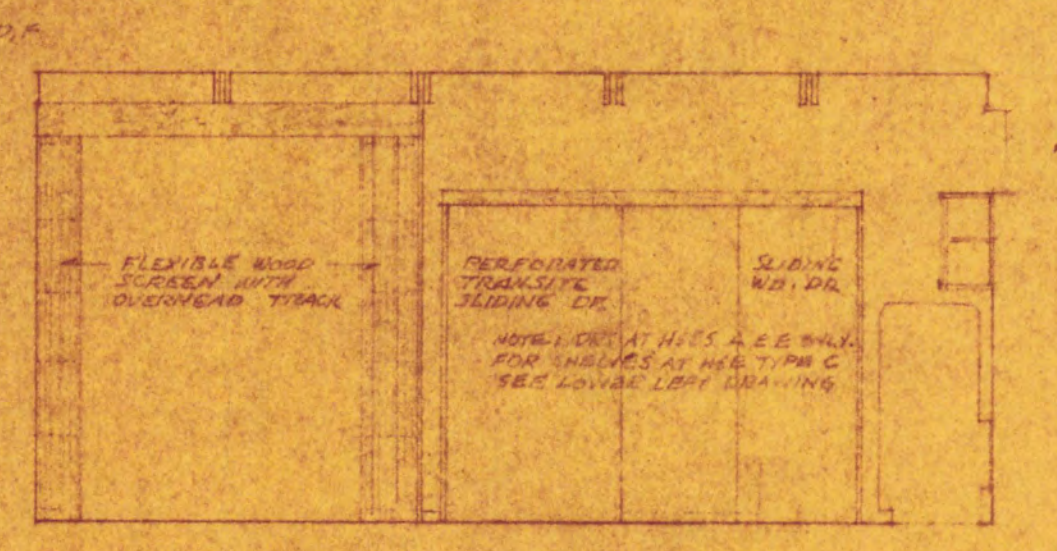


DINING ROOM KITCHEN HOUSE TYPES B, D, F

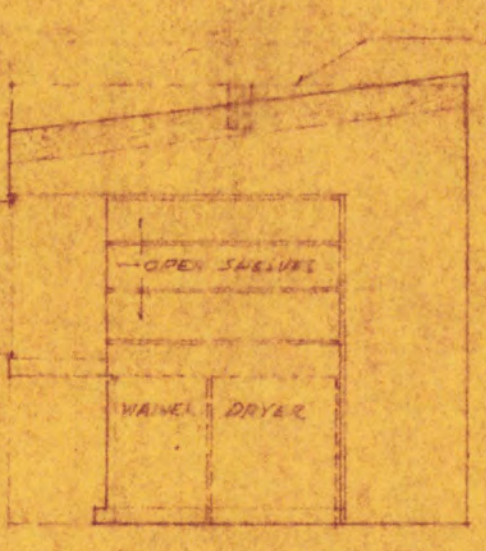


KITCHEN HOUSE TYPE D

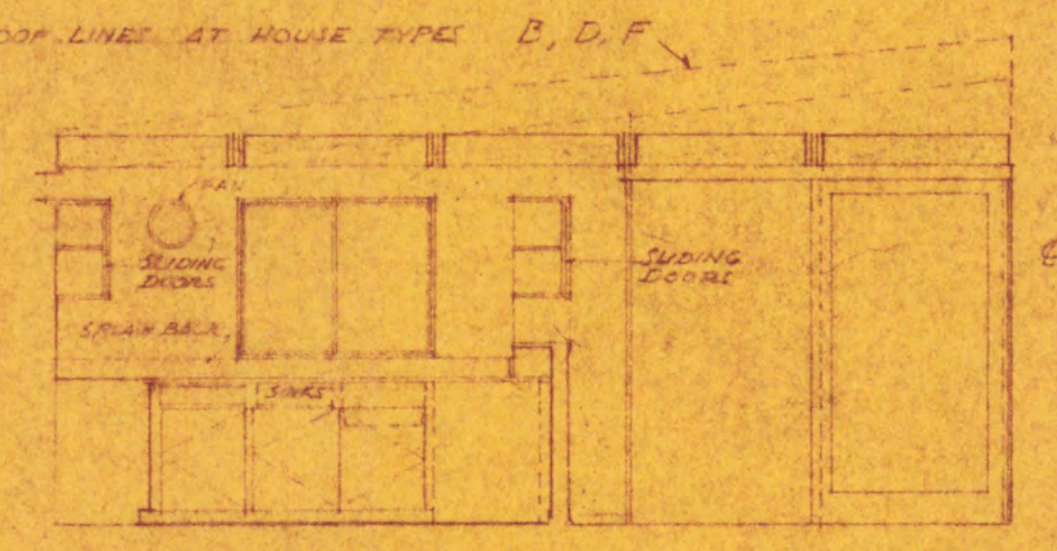


KITCHEN HOUSE TYPES A, C, E

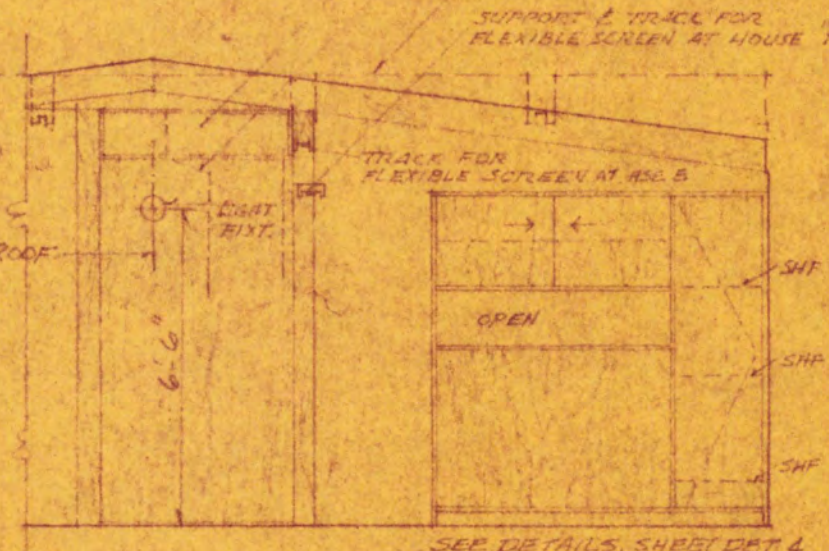


DINING ROOM HOUSE TYPE E

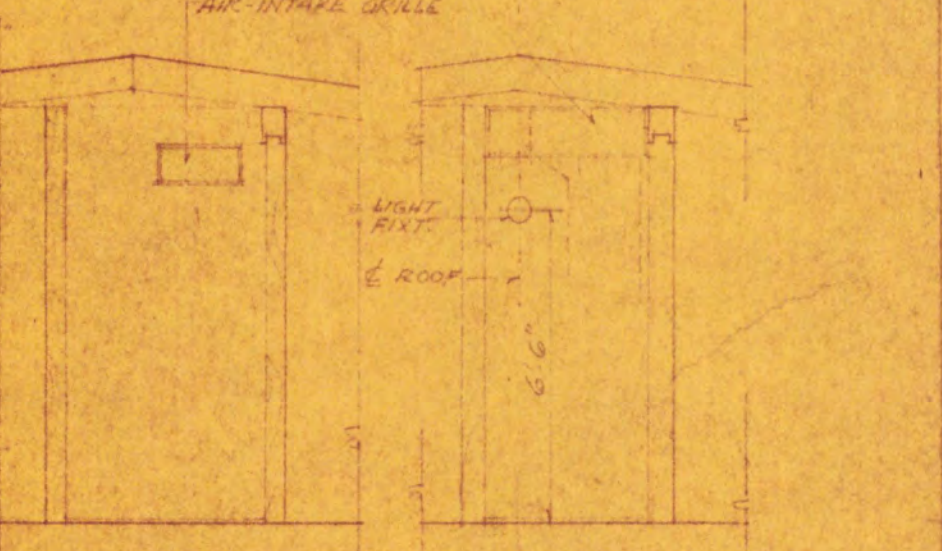


BETWEEN DINING & LIVING RMs HOUSE TYPE A HOUSE TYPE C

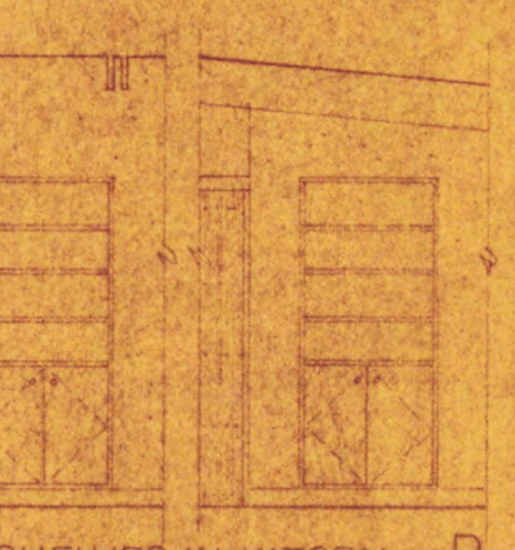


CAB & SHELVES IN KITCHEN HOUSE TYPE B HOUSE TYPE D

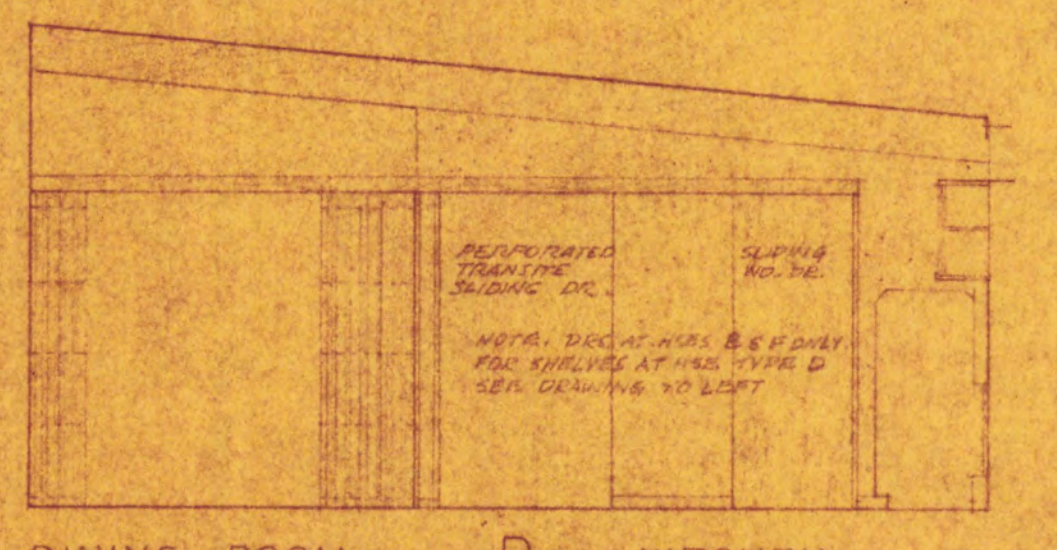


DINING ROOM KITCHEN HOUSE TYPES B, D, F

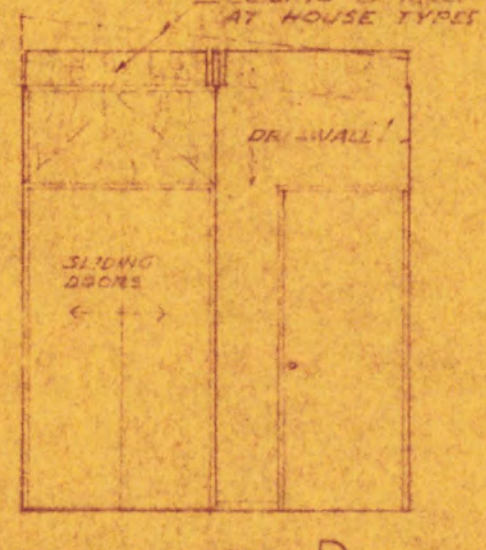


BED RM 3 HOUSE TYPES B, D, F

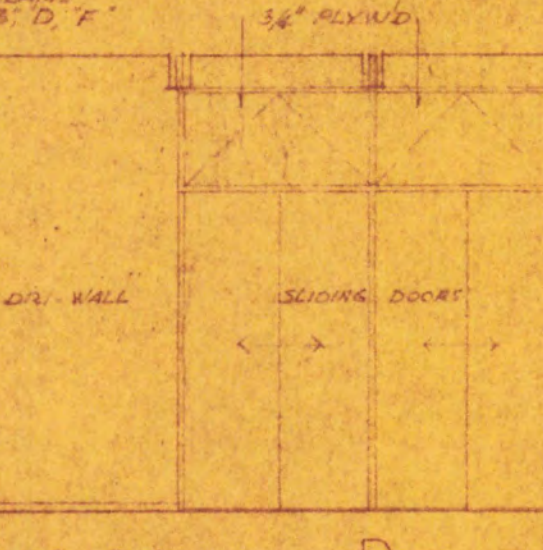


BED RM 1 HOUSE TYPES A, C, E

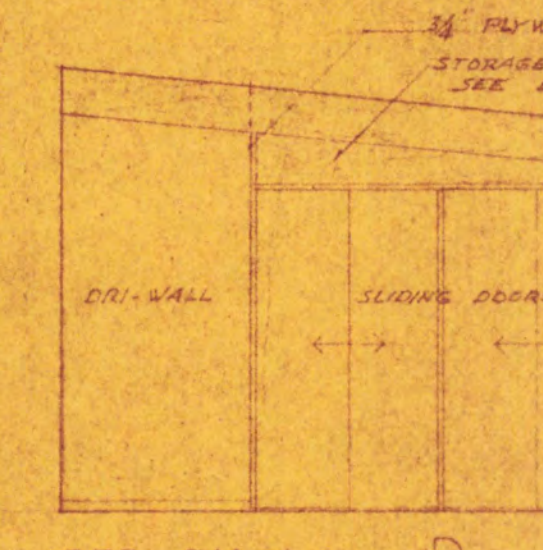


BED RM 1 HOUSE TYPES B, D, F

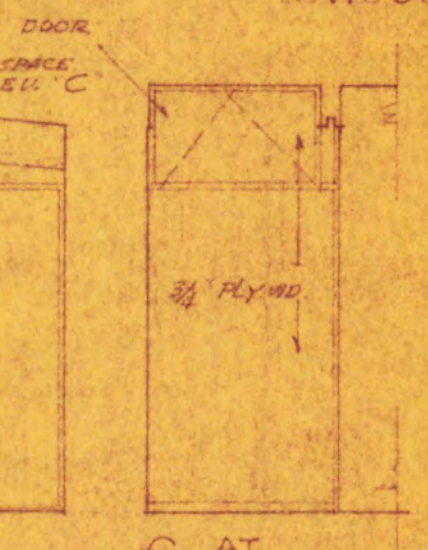

ENTRY BR-1 TYPES B, D, F

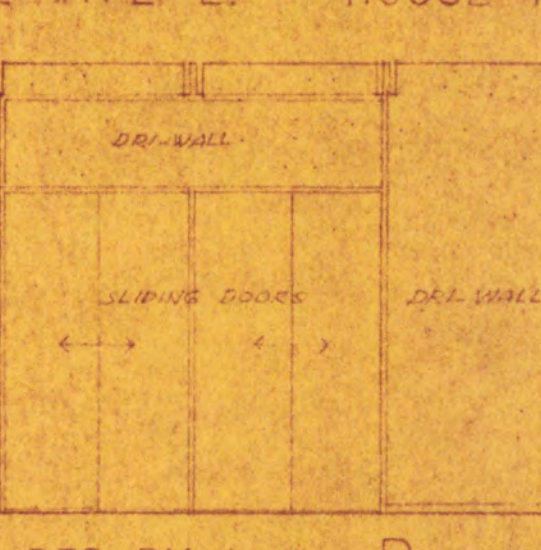


BED RM 1 HOUSE TYPES A, C, E

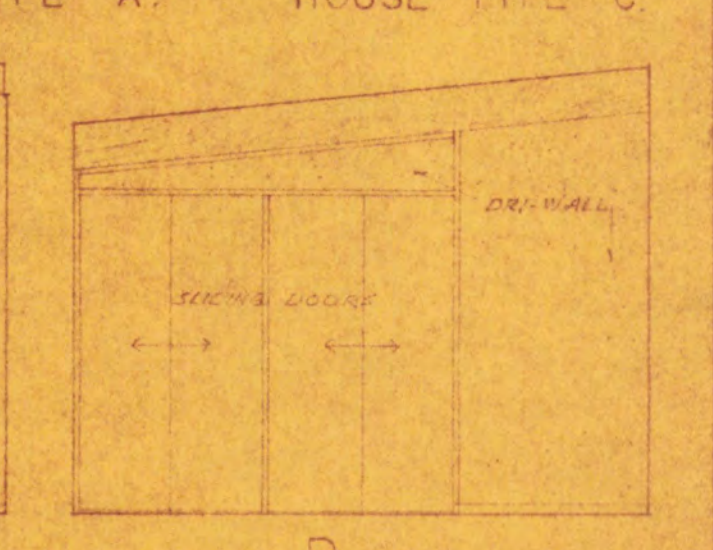


BED RM 1 HOUSE TYPES B, D, F

FOR KEY TO ELEVATIONS SEE 1/4" SCALE PLANS

PINE SPRING - LURIA BROS - BUILDERS		JOB	52-02
LEE BLVD - LEE HIGHWAY - FAIRFAX COUNTY, VA		SH.	
INTERIOR ELEVATIONS		DET-1	
SCALE: 1/4" = 1'-0" DATE: 5/12/52 DRAWN BY: M.G. CHECKED BY:		OF	
KEYES, SMITH & SATTERLEE - ARCHITECTS			
FRANCIS D. LETHBRIDGE - ASSOCIATE			
THREE DUPONT CIRCLE - WASHINGTON 6, D. C. - HOBART 3315			

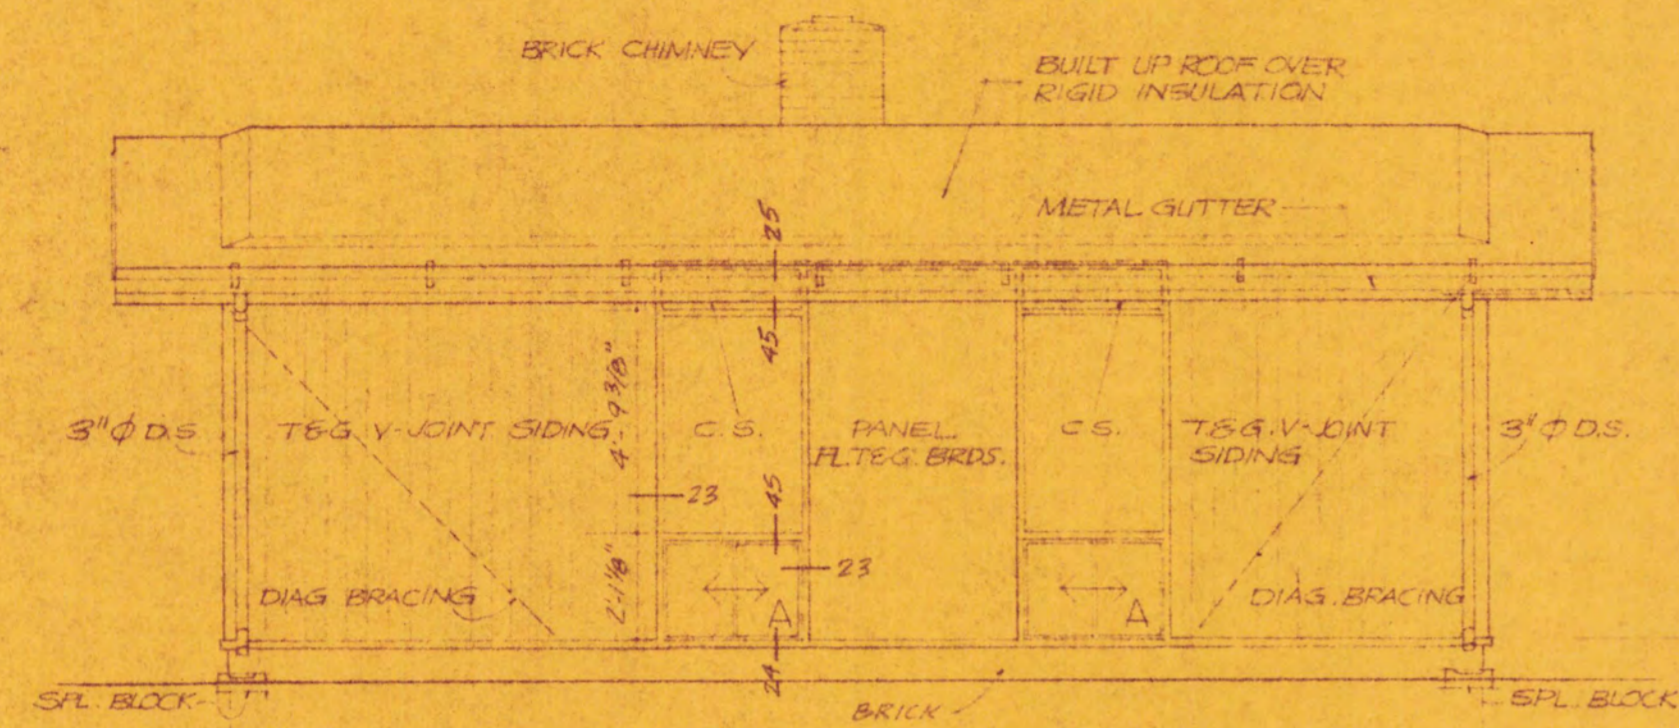


ELEVATION C

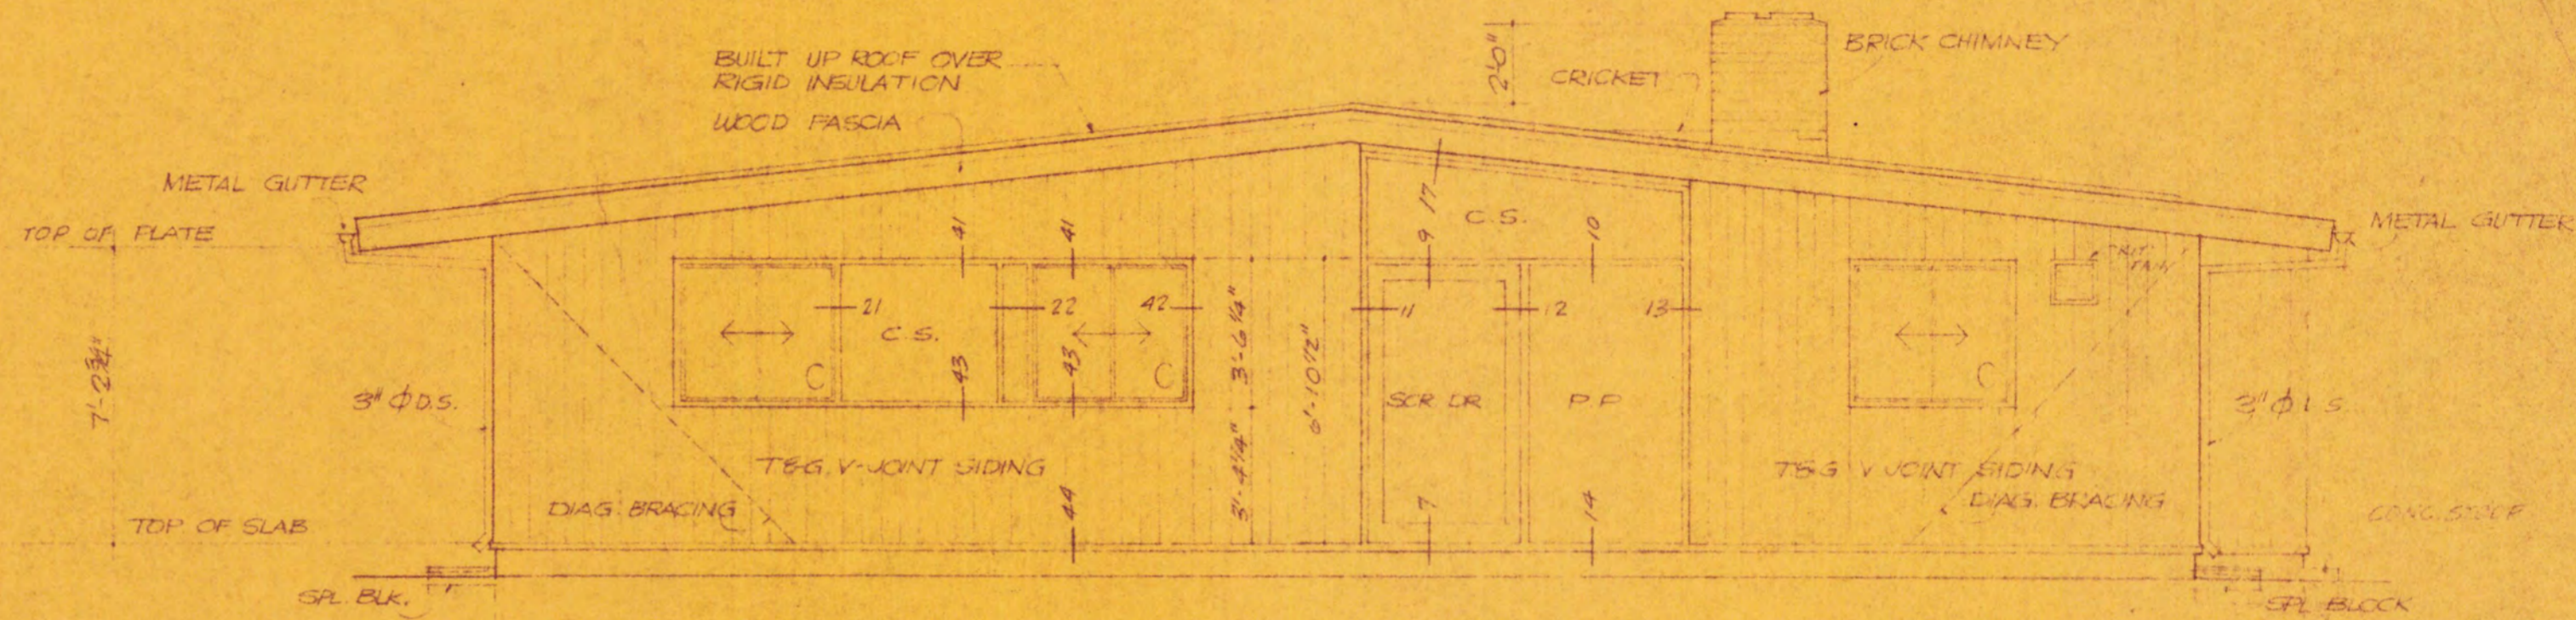


ELEVATION D

DIAGONAL BRACING SHOWN IS 1"X4" LET IN TO EXTERIOR FACE OF STUDS

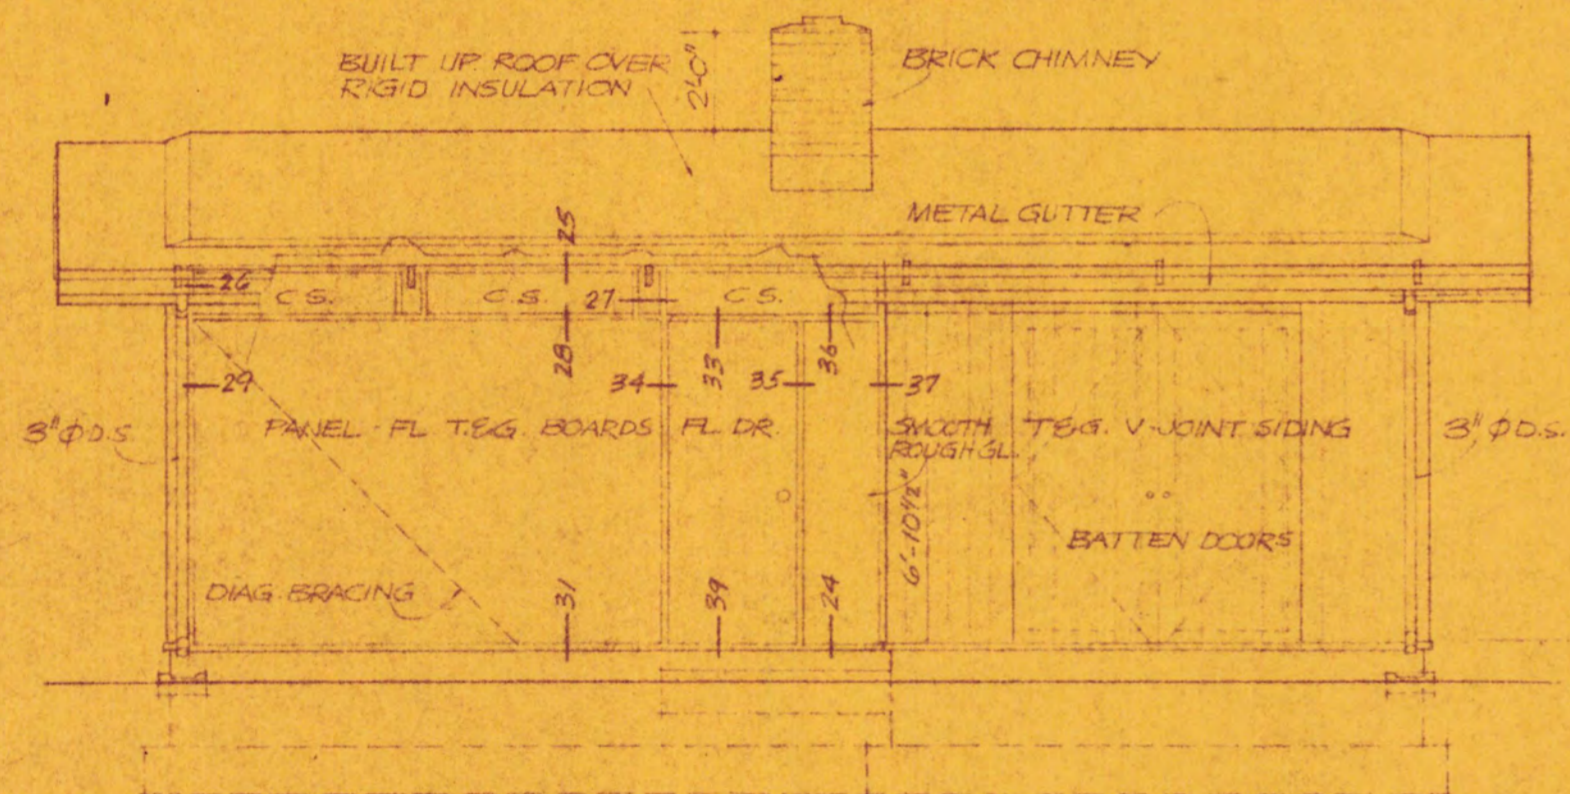

ELEVATION A

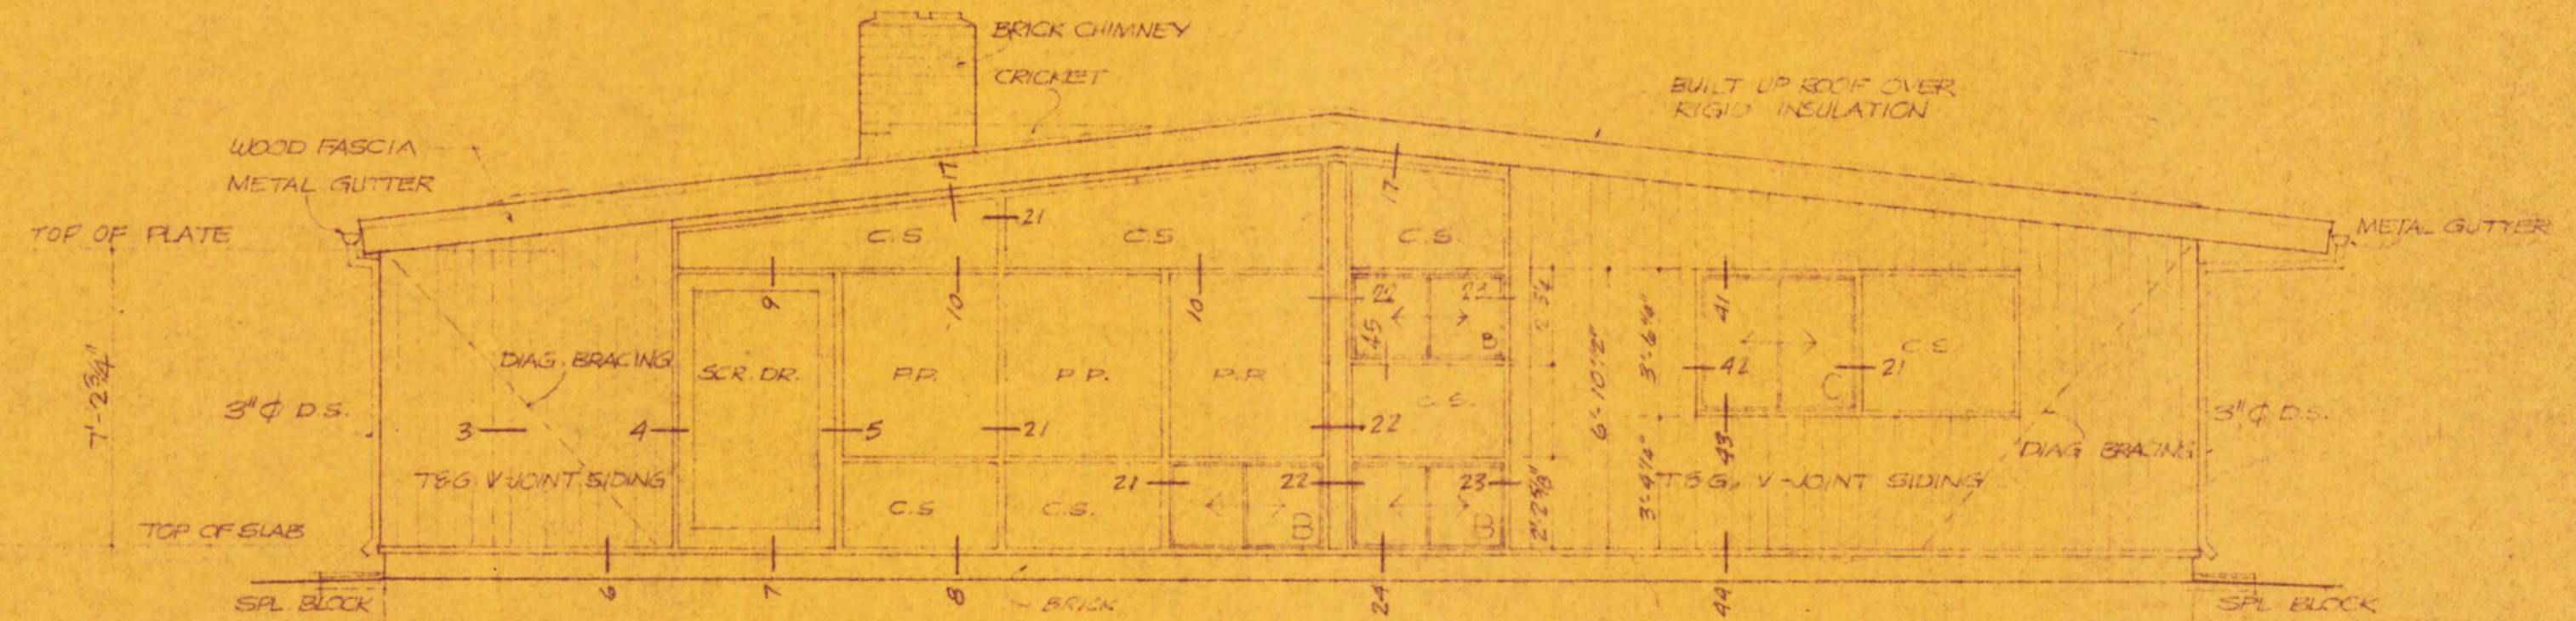


ELEVATION B


HOUSE TYPE B

REVISIONS:
9/9/52: CONTINUOUS EXPOSED SILL




—	PINE SPRING-LURIA BROS - BUILDERS	52-02
—	LEE BLVD - LEE HIGHWAY - FAIRFAX COUNTY, VA	
ELEVATIONS ALTERNATE ROOF HOUSE		
SCALE 1/4" = 1'-0" DATE 8/13/52 DRAWN BY DC		
NEYES, SMITH & SATTENLEE - ARCHITECTS		B-2
FRANCIS D. LETHBRIDGE		
THREE DUPONT CIRCLE - WASHINGTON 6, D. C.		

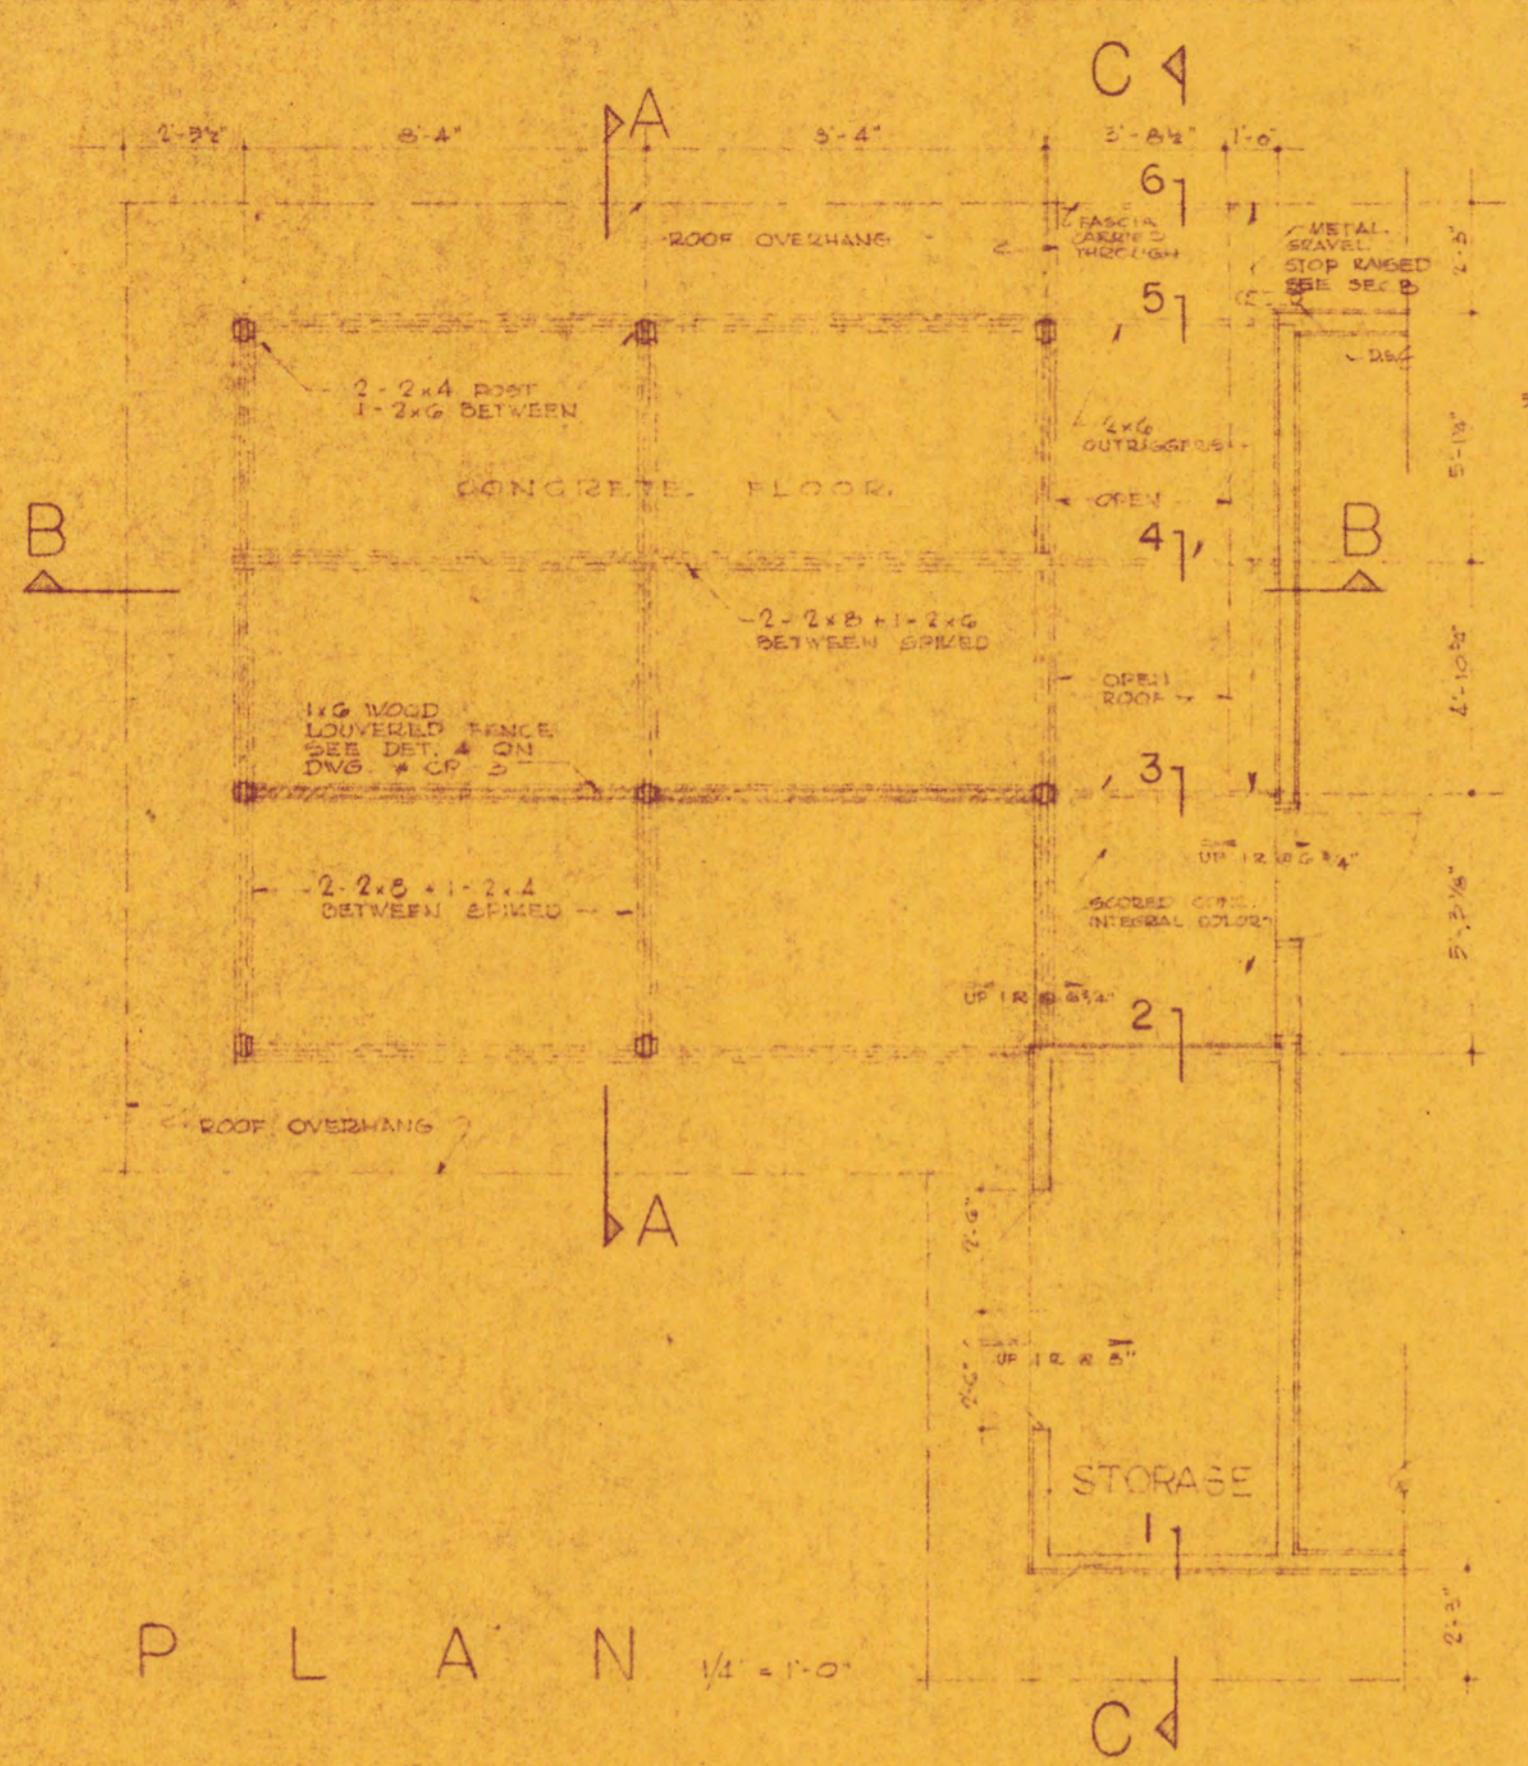


PLAN 1/4" = 1'-0"

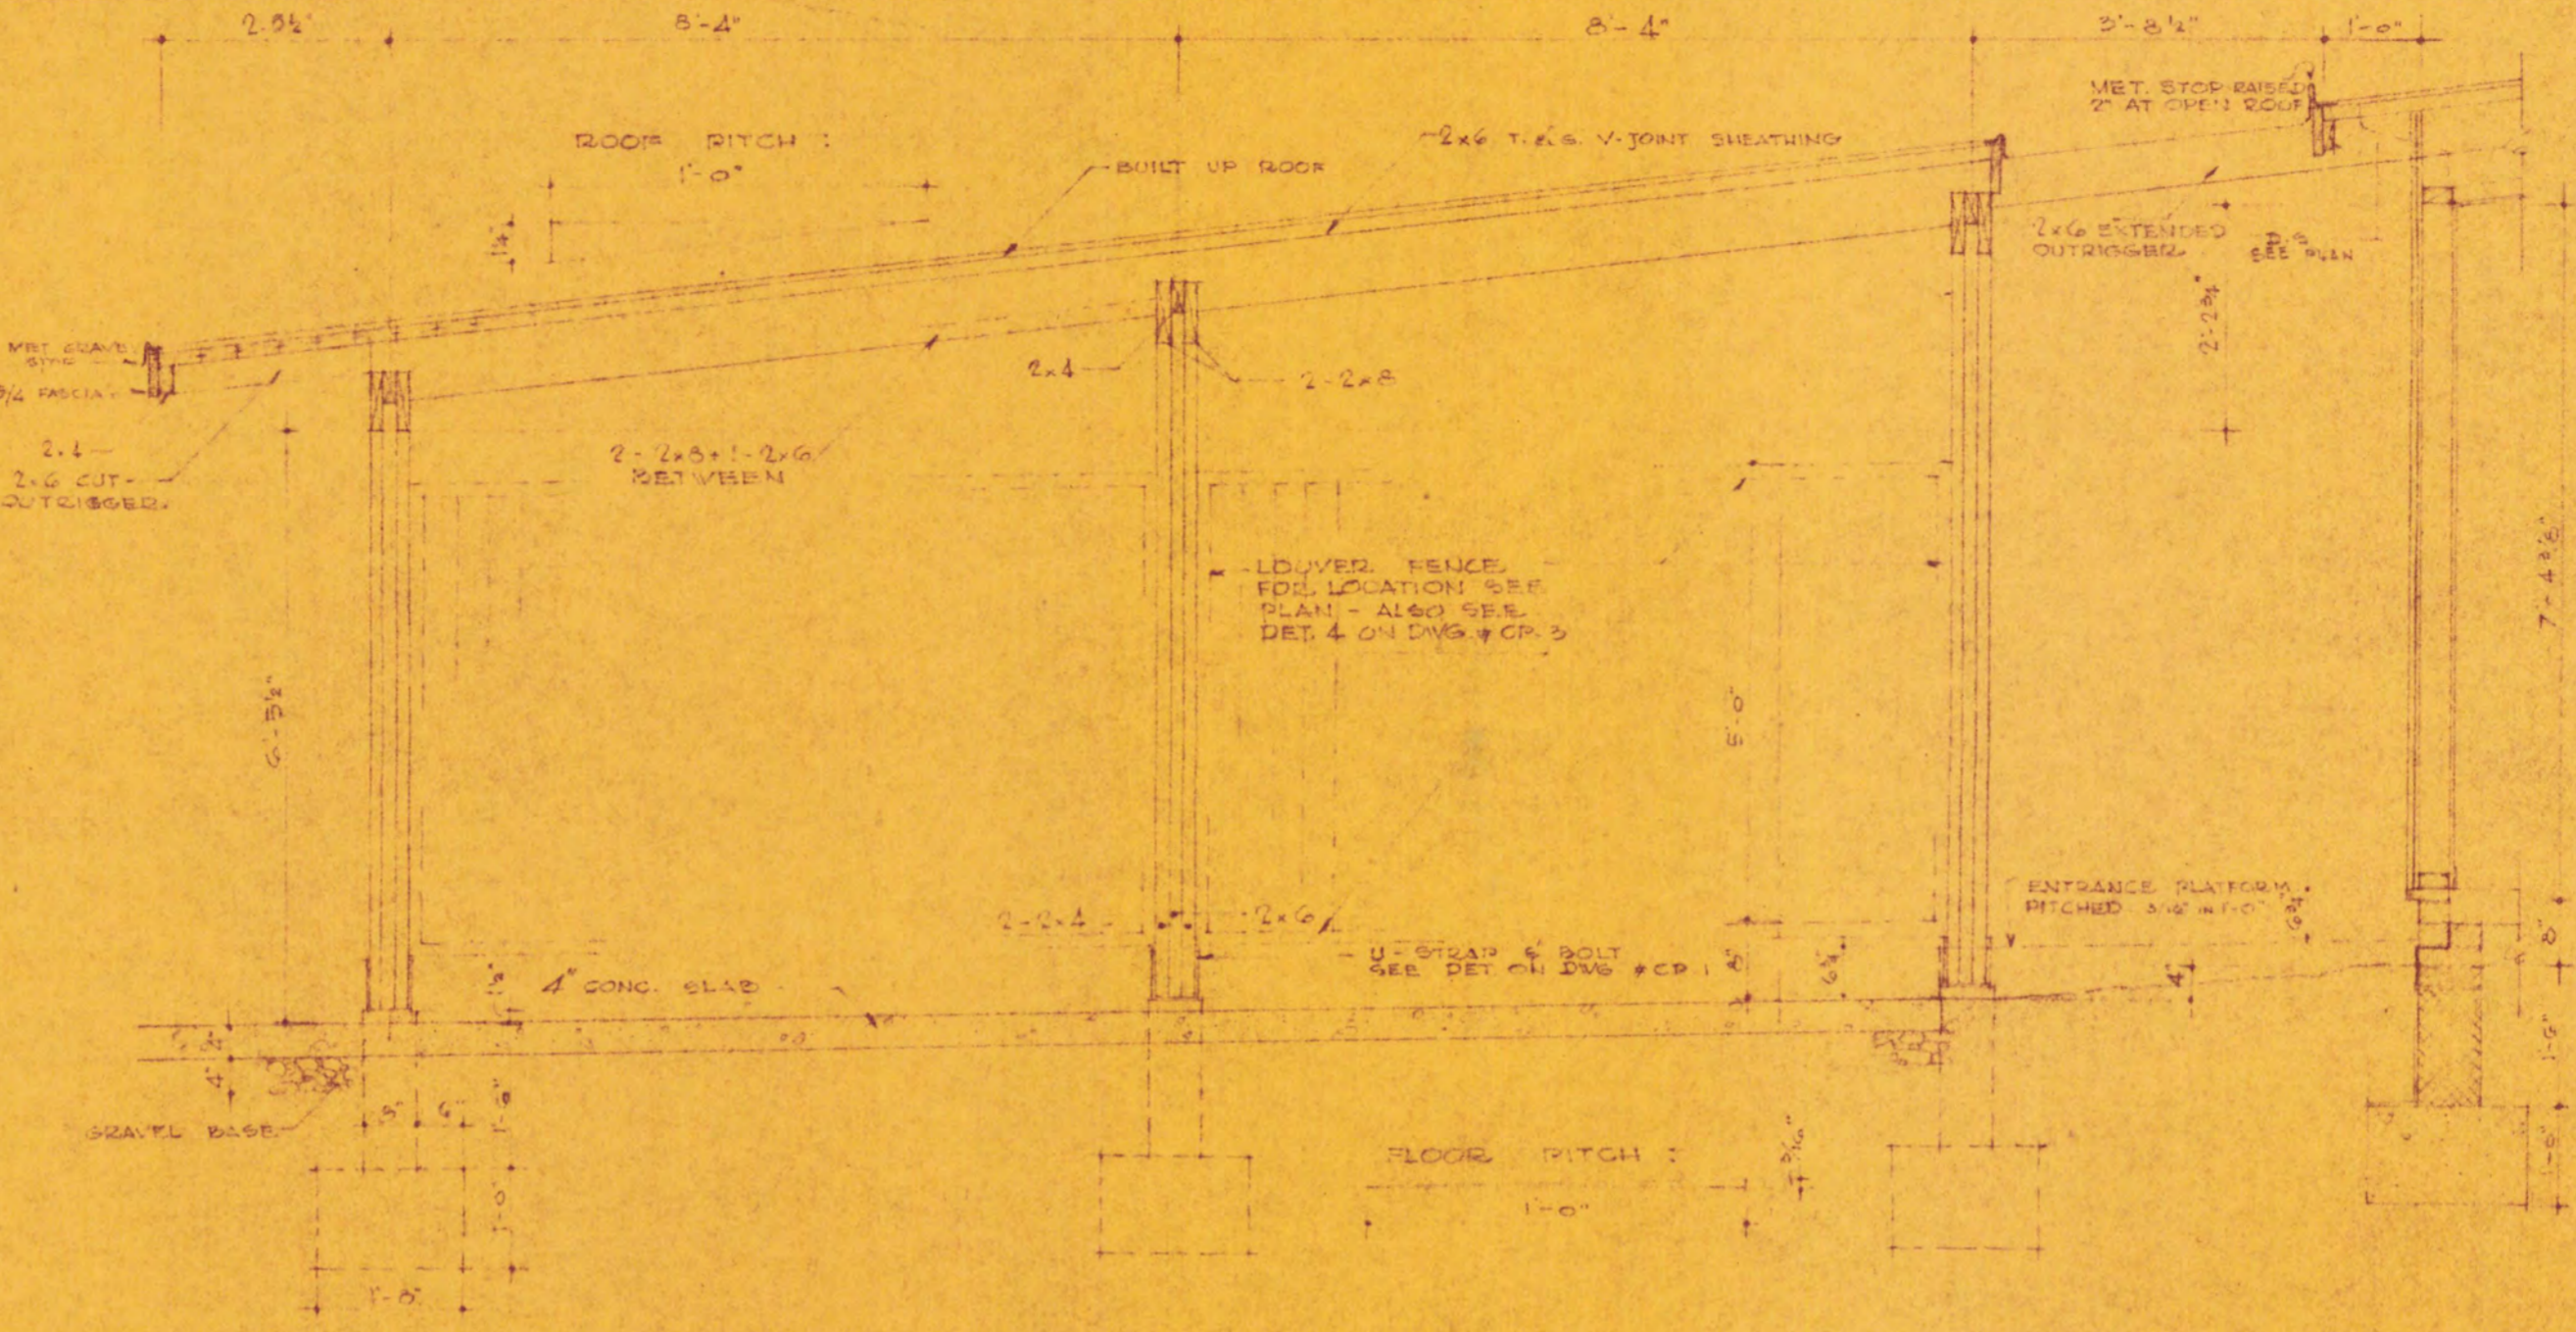


SECTION B 1/2" = 1'-0"

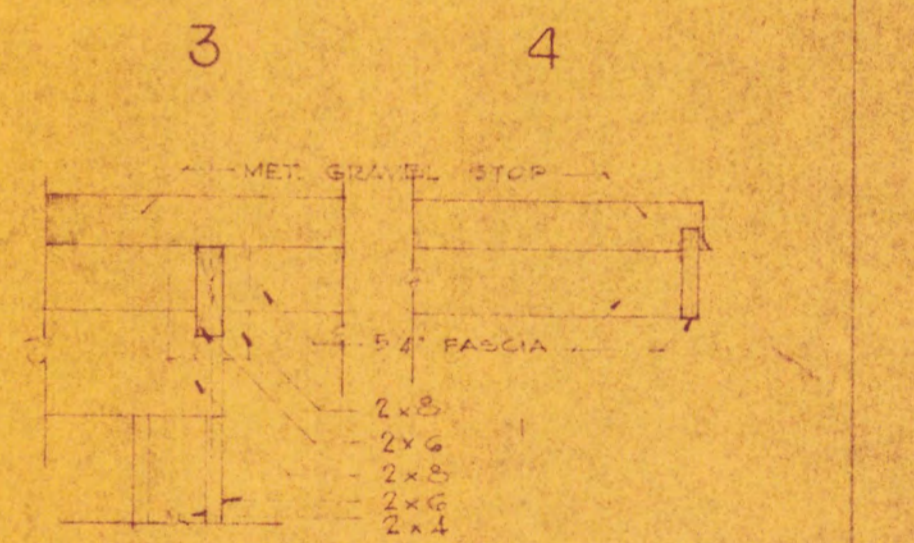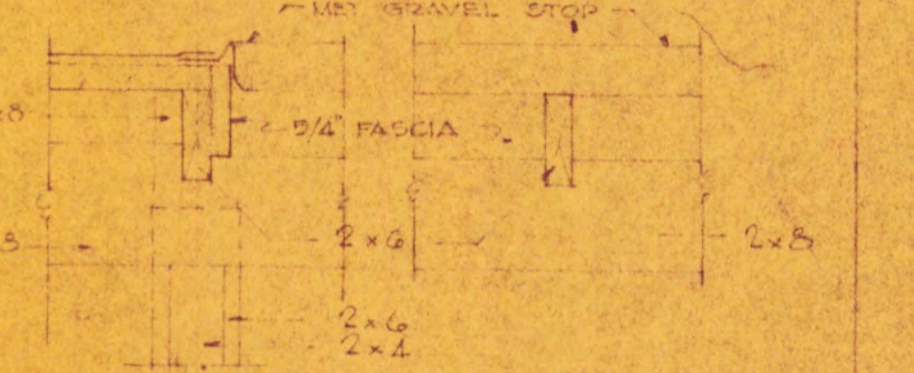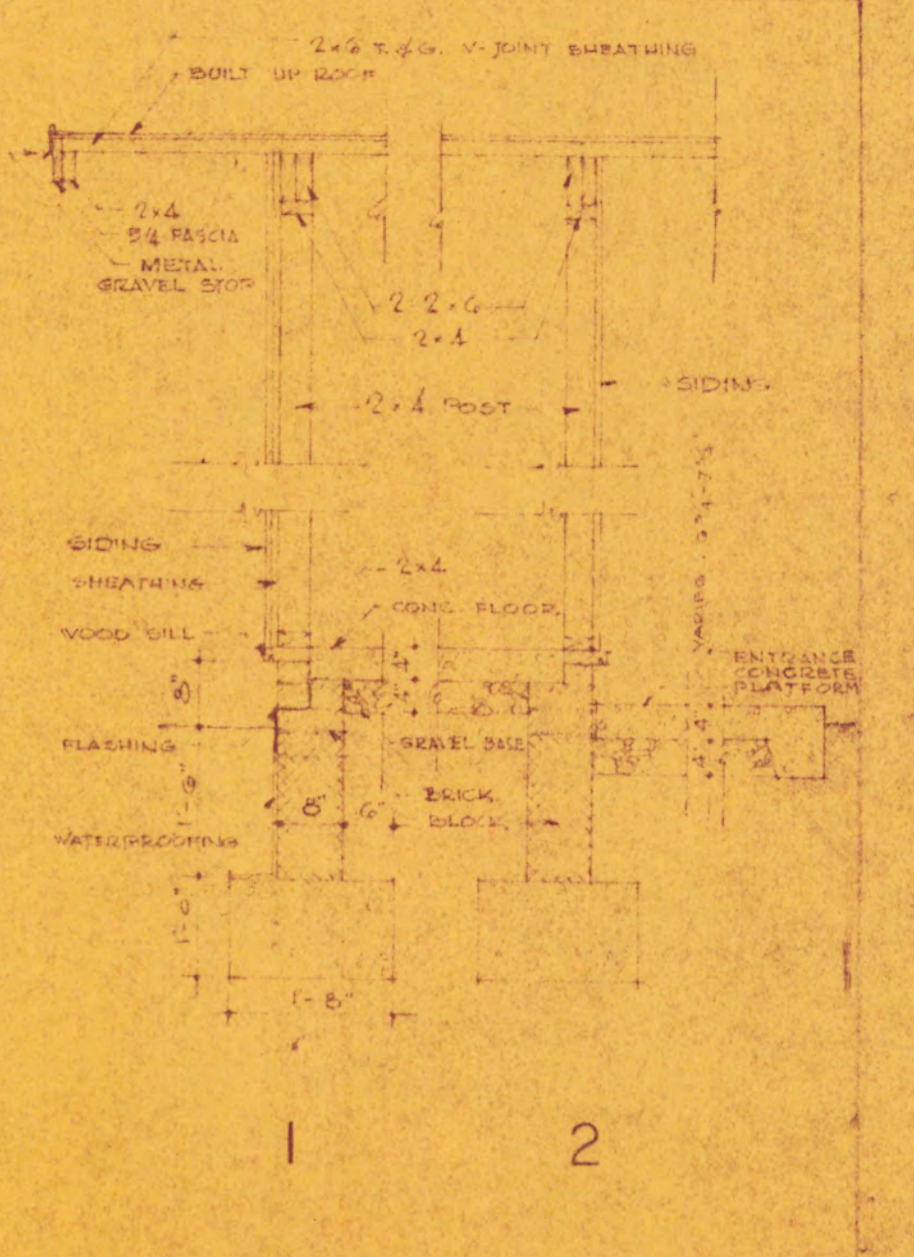


SECTION C 1" = 1'-0"

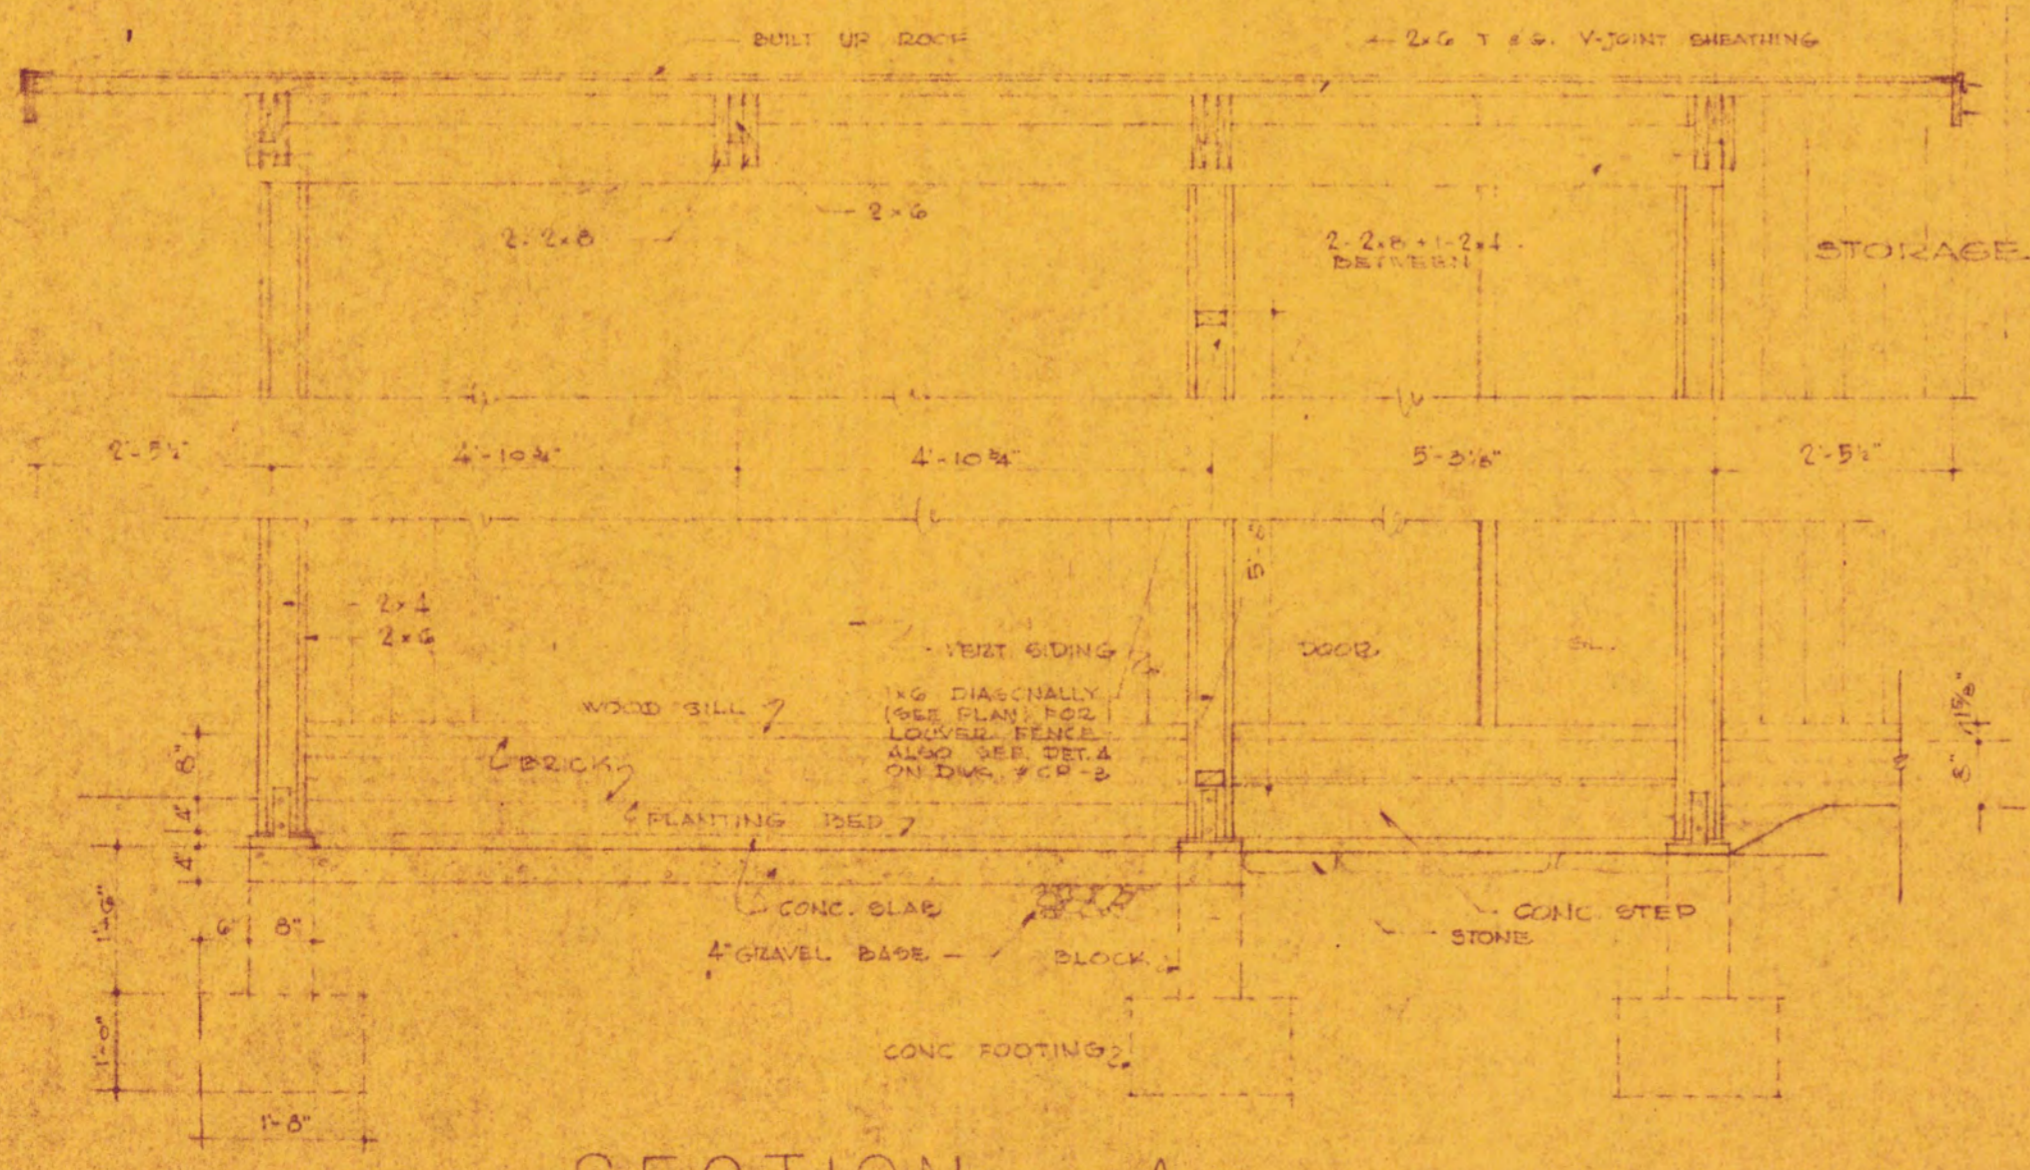

SECTION A 1/2" = 1'-0"

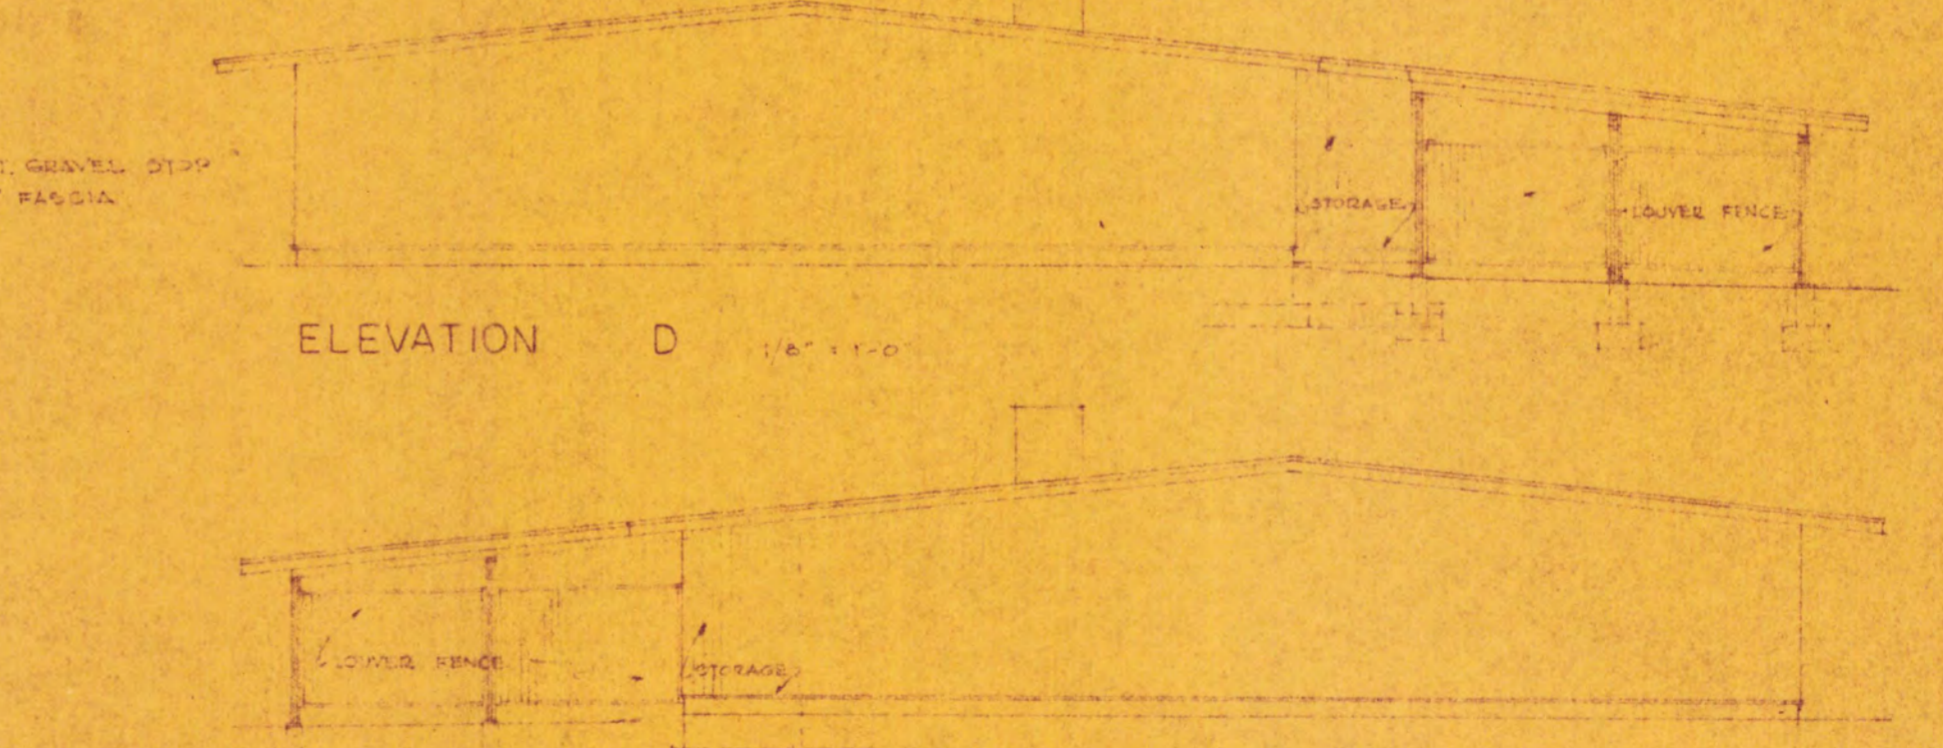


ELEVATION D 1/8" = 1'-0"

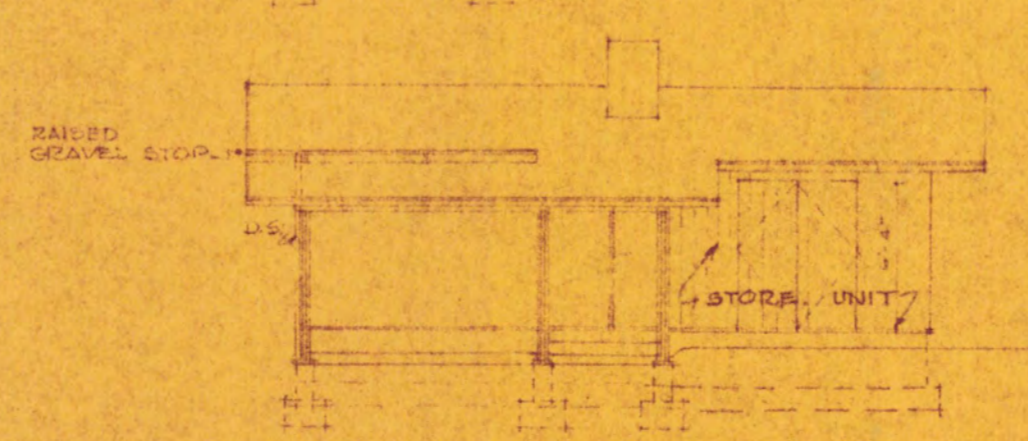


ELEVATION A 1/8" = 1'-0"

PINE SPRING - LURIA BROS. BUILDERS		JOB
LEE BLVD. - LEE HIGHWAY - FAIRFAX COUNTY, VA		52-02
CAR PORT 10 FOR H'SE TYPE-B		SH.
SCALE AS SHOWN DATE 5/3/52 DRAWN BY: T.H. CHECKED BY:		CP-6
KEYES, SMITH & SATTERLEE - ARCHITECTS		OF
FRANCIS D. LETHBRIDGE - ASSOCIATE		
THREE DUPONT CIRCLE - WASHINGTON 8, D. C. - HOBART 3375		

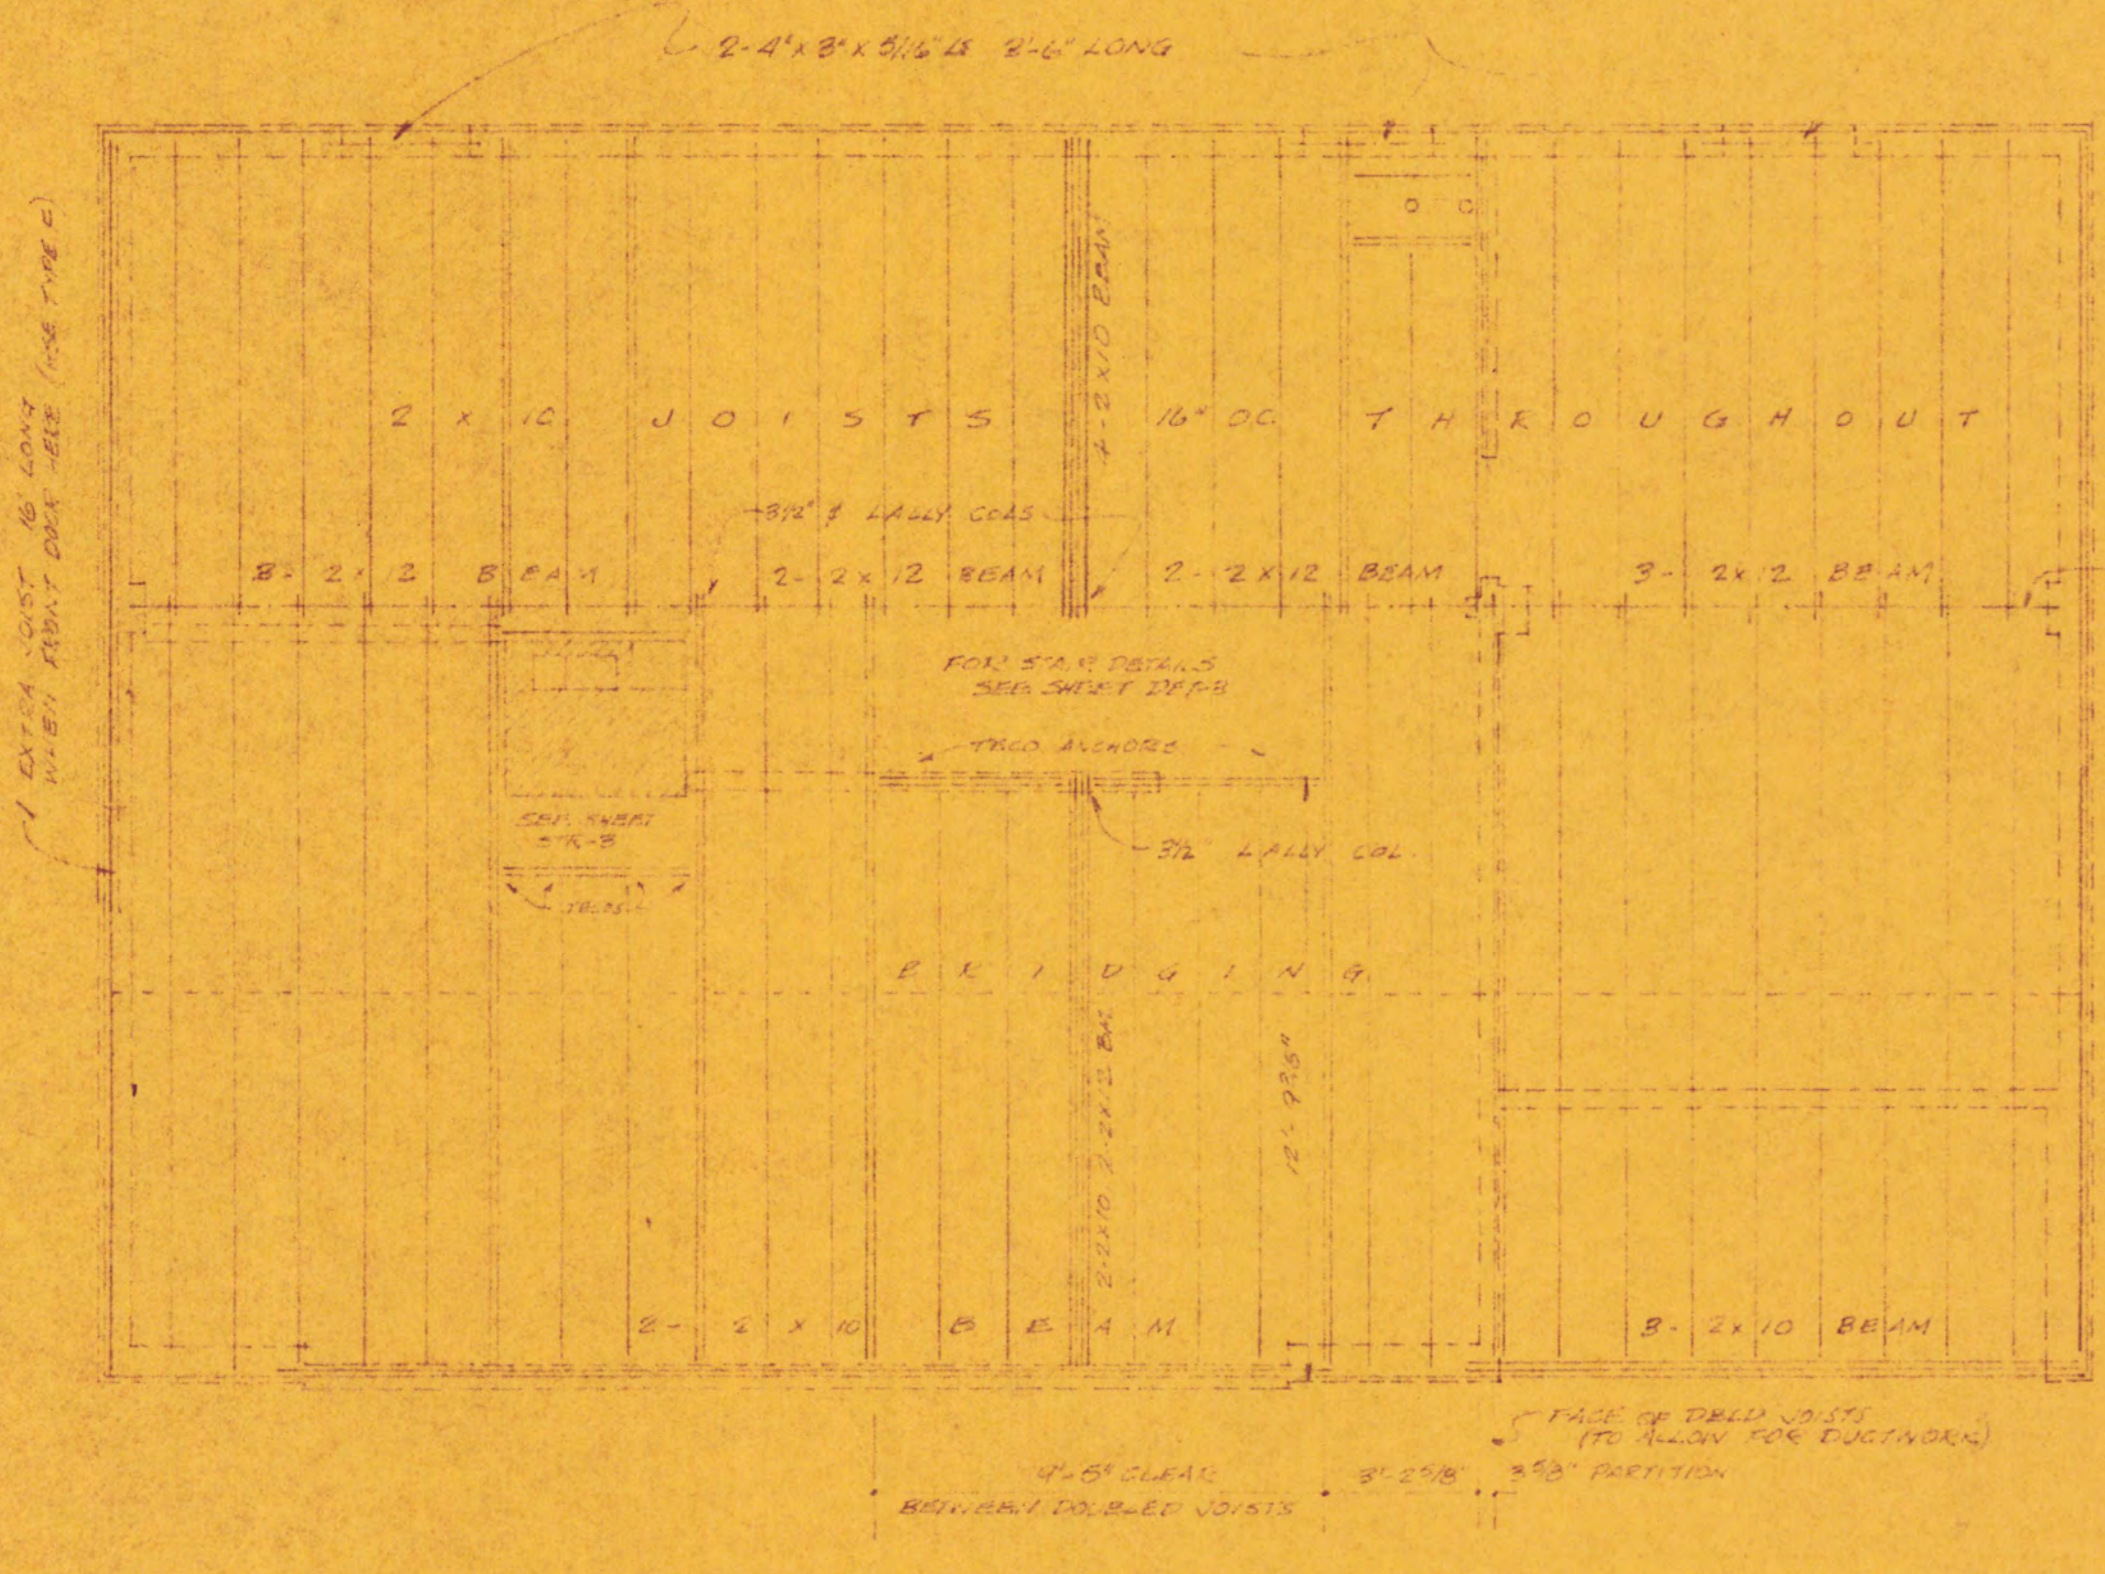

FLOOR FRAMING

HOUSE TYPES D & F




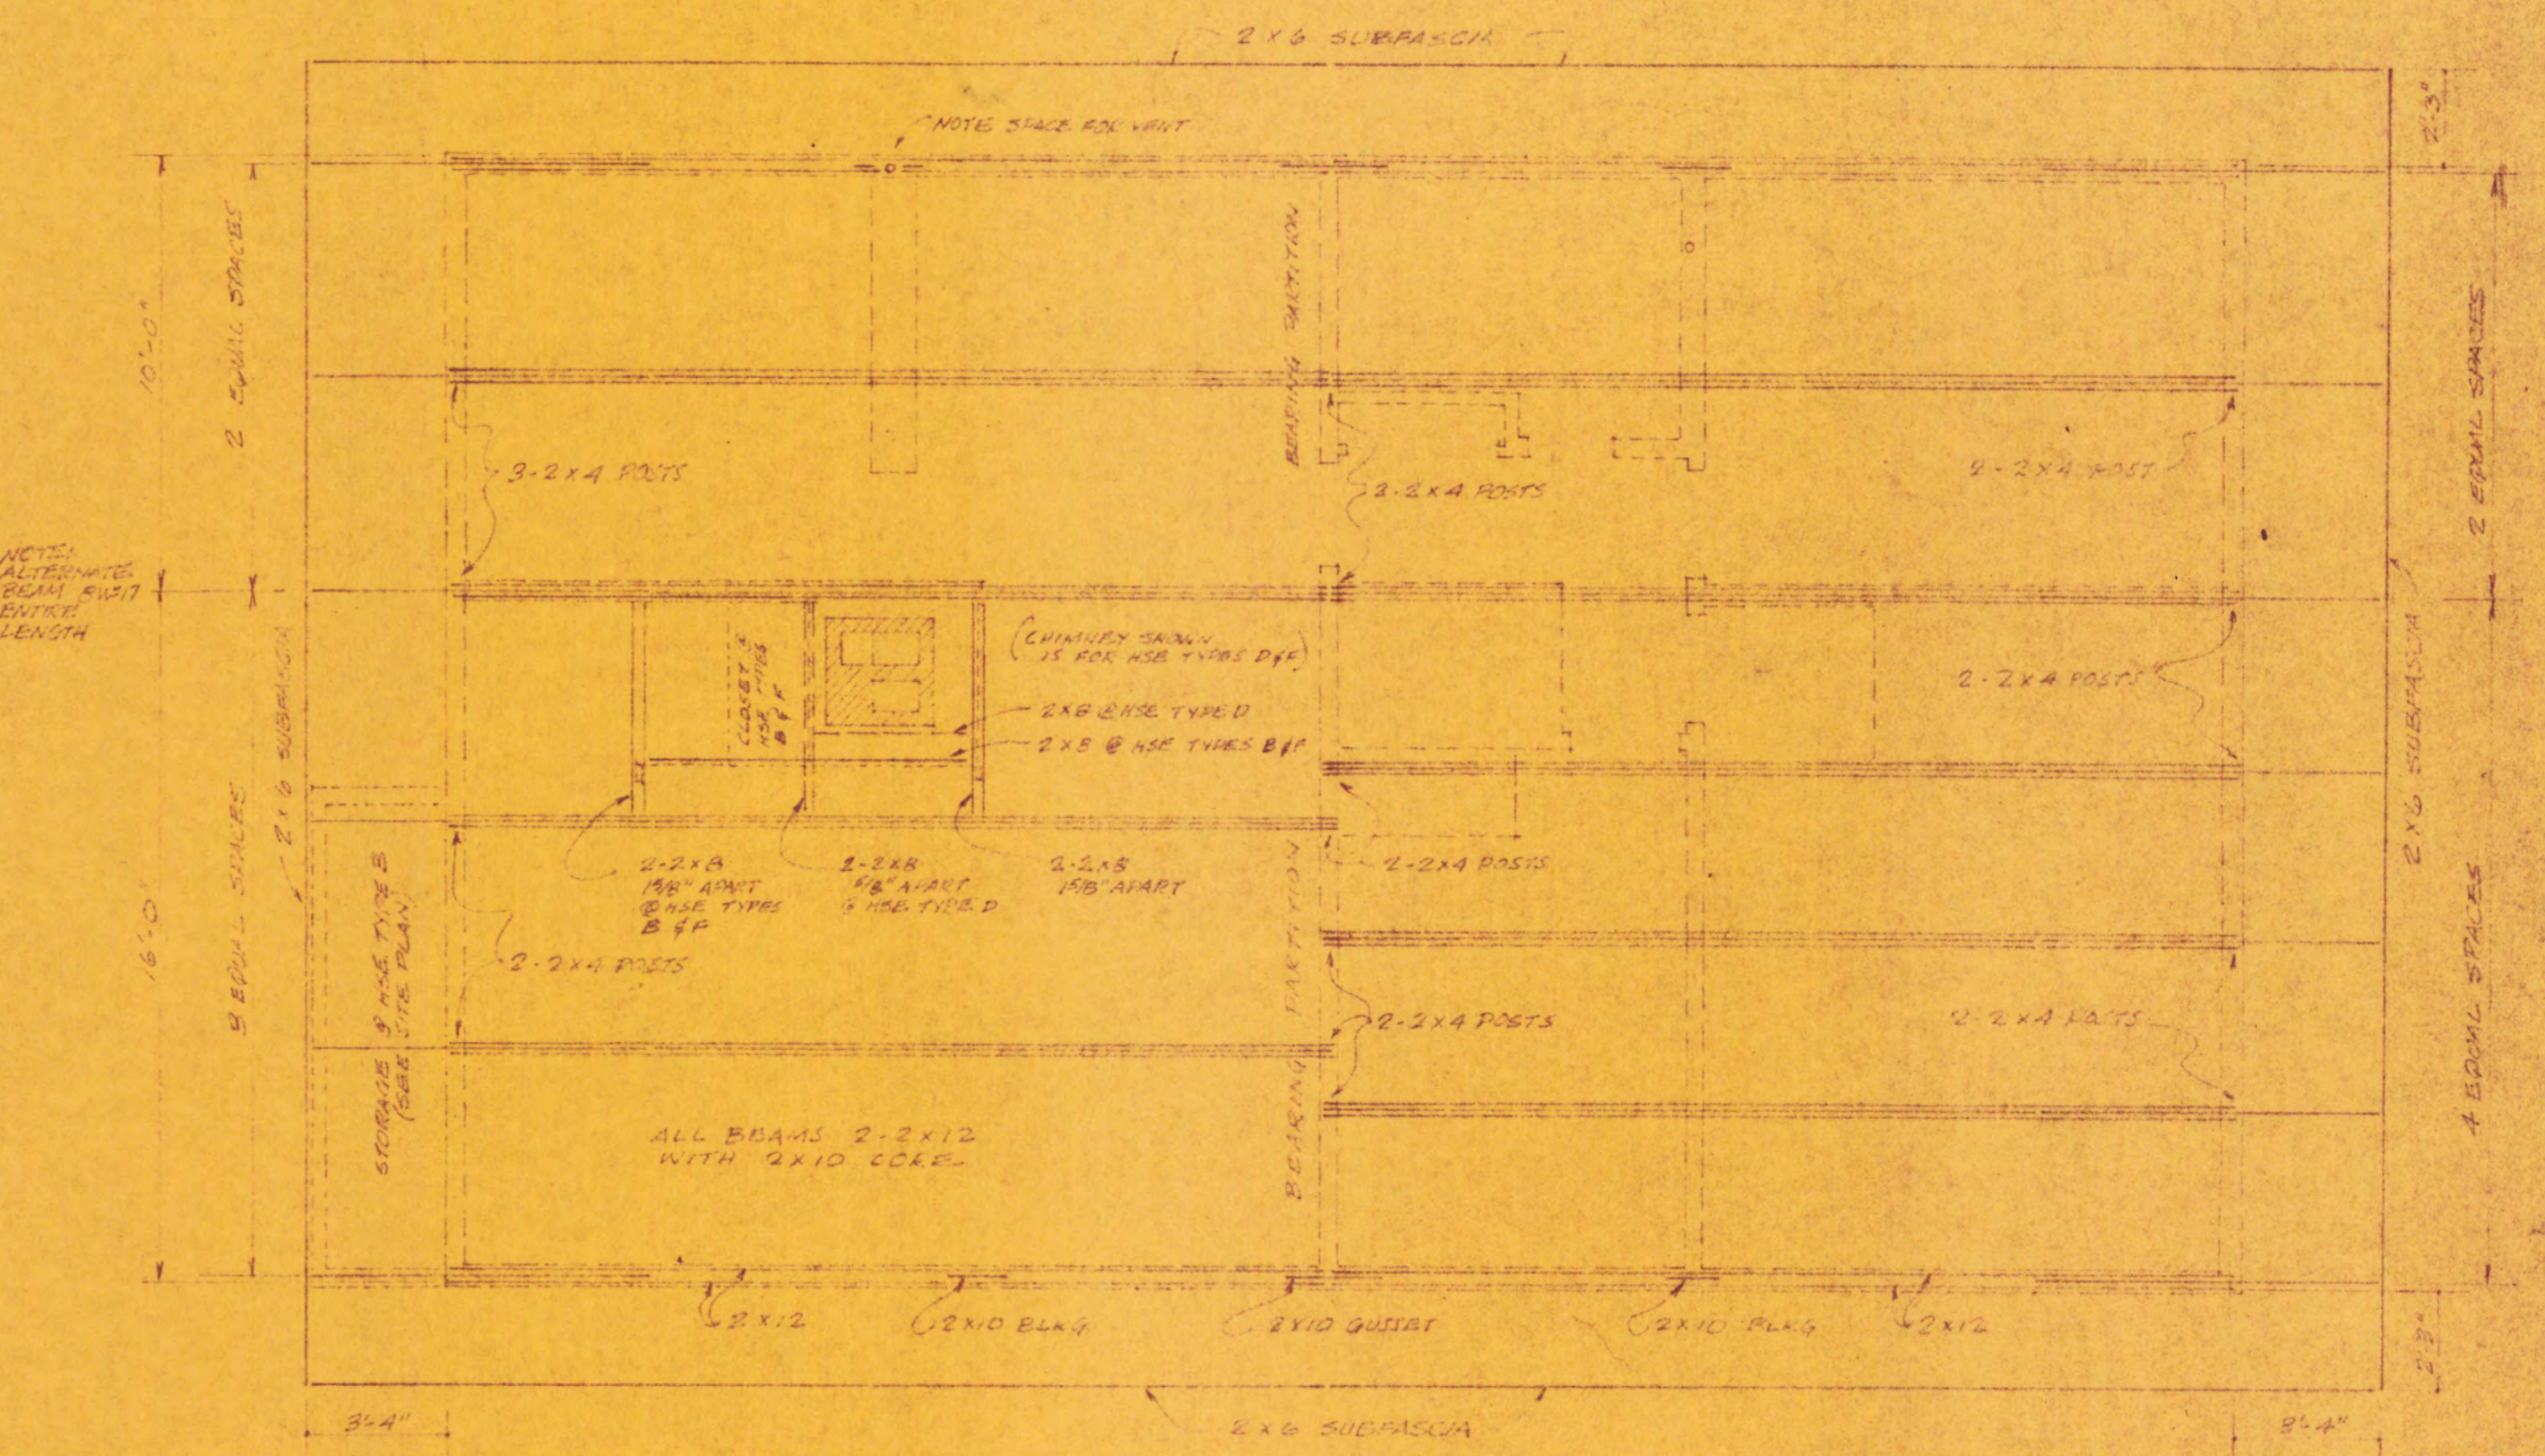


ROOF FRAMING

HOUSE TYPES B, D & F

PINE SPRING - LURIA BROS. BUILDERS		JOB 52 02
LEE BLVD. - LEE HIGHWAY - FAIRFAX COUNTY, VA.		
FRAMING PLANS ALTERNATE ROOF HOUSES		STR-2
CHECKED BY: L.M.		
KEYES, SMITH & BATTERLEE - ARCHITECTS		OFF
LAWRENCE D. LEE - ARCHITECT		
THREE DUPONT CIRCLE - WASHINGTON 6, D. C. - CHART 1916		

27

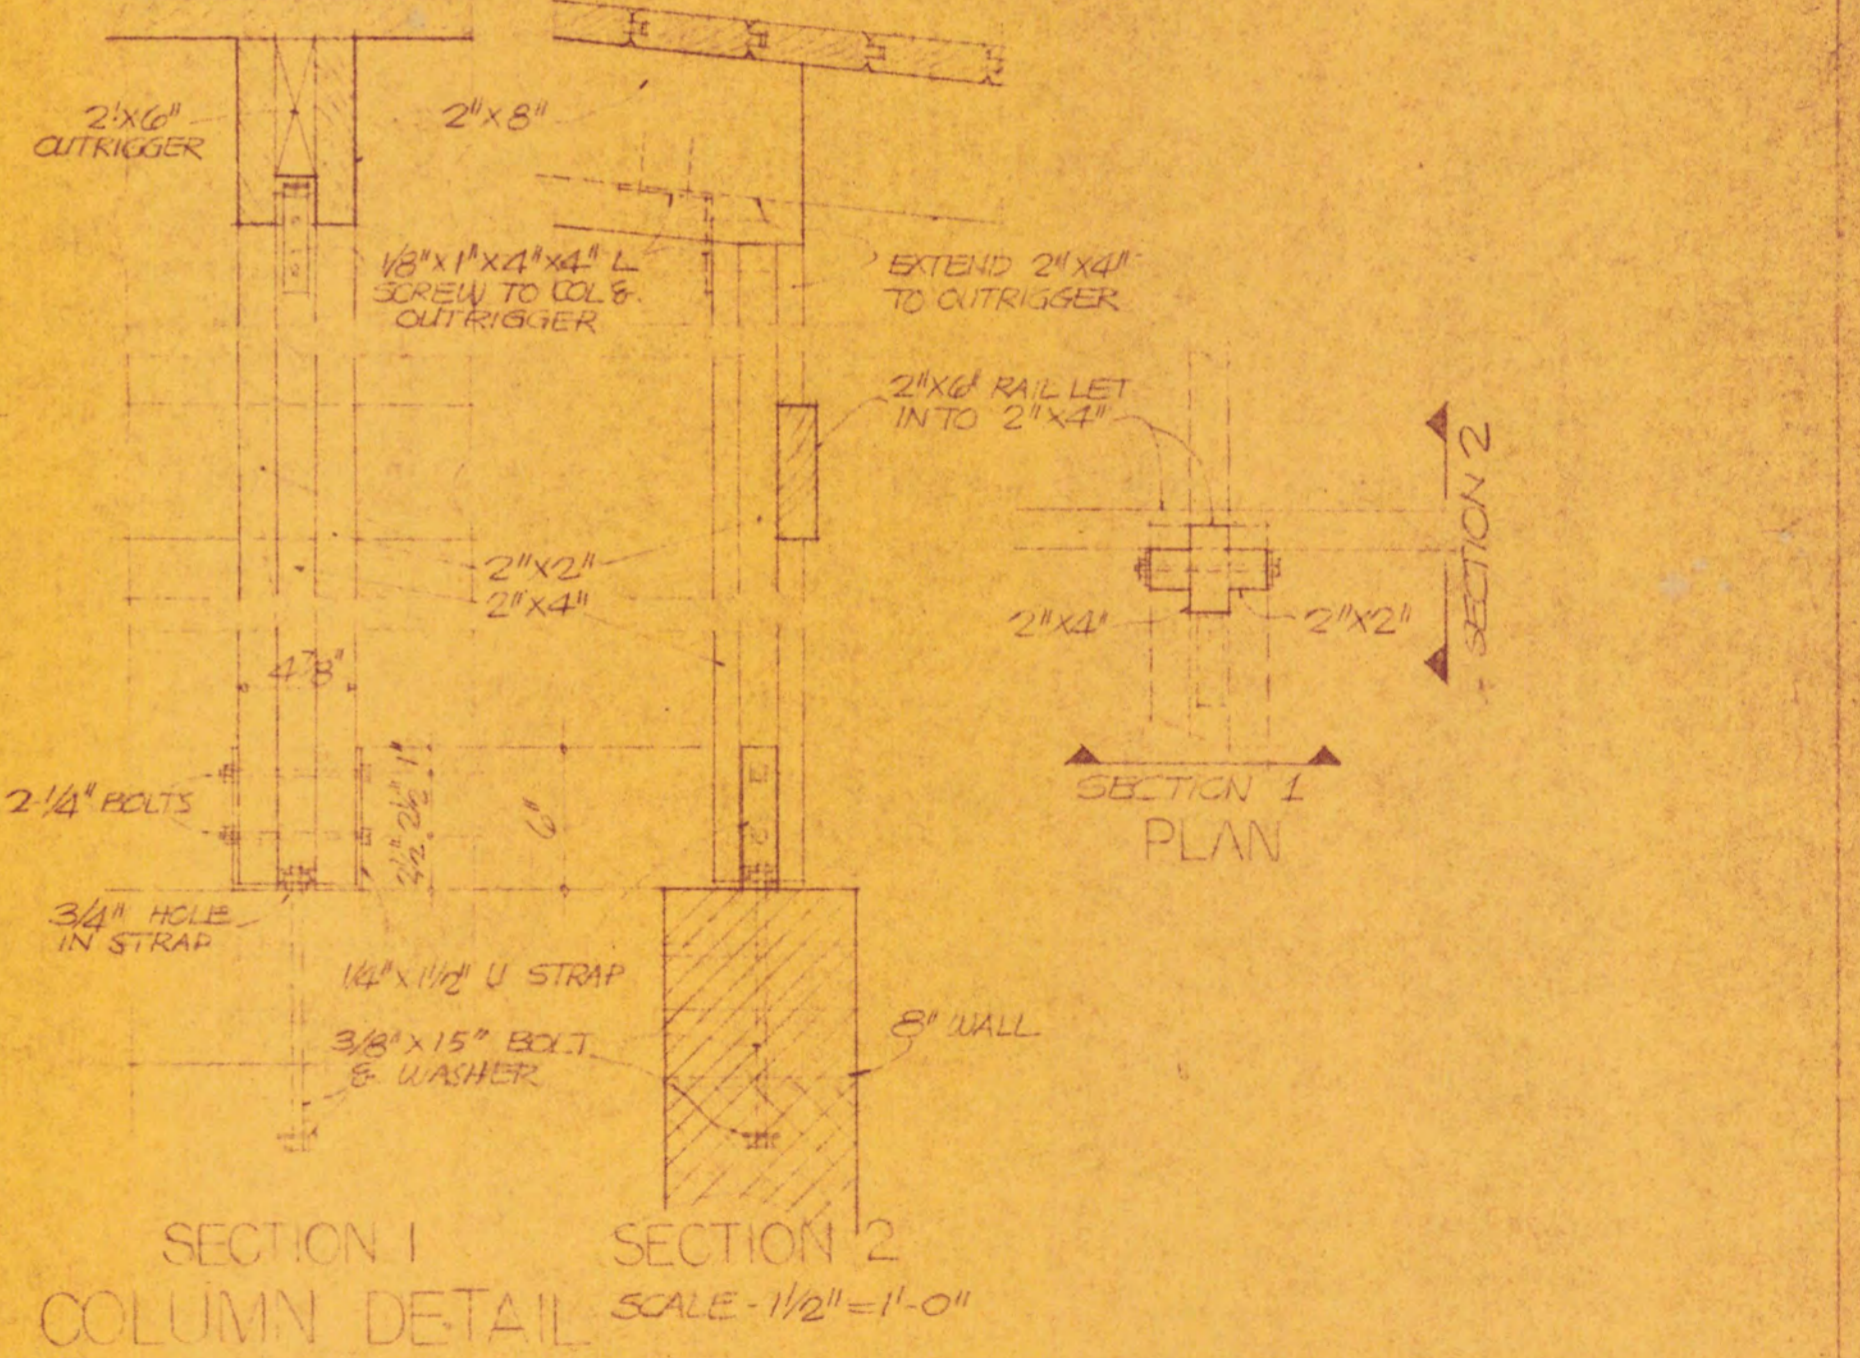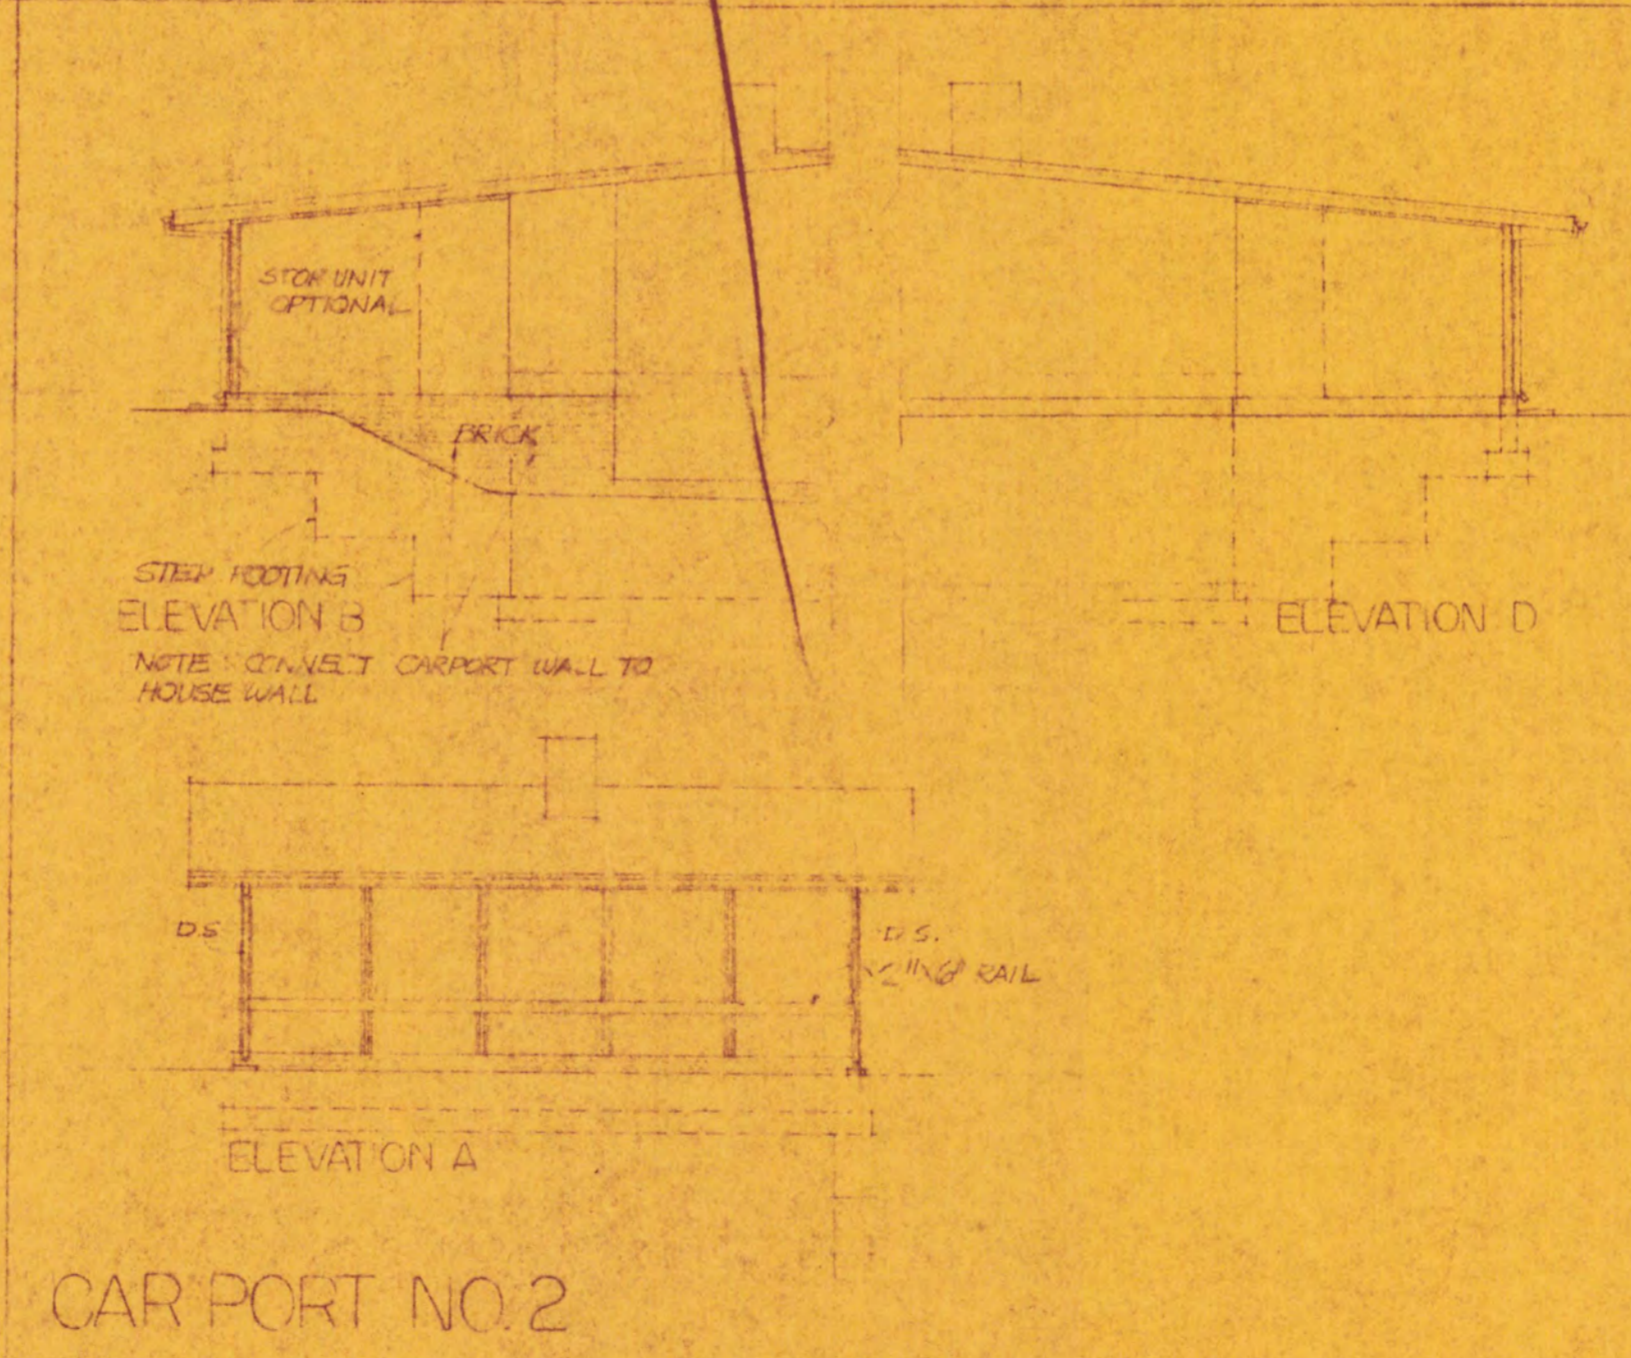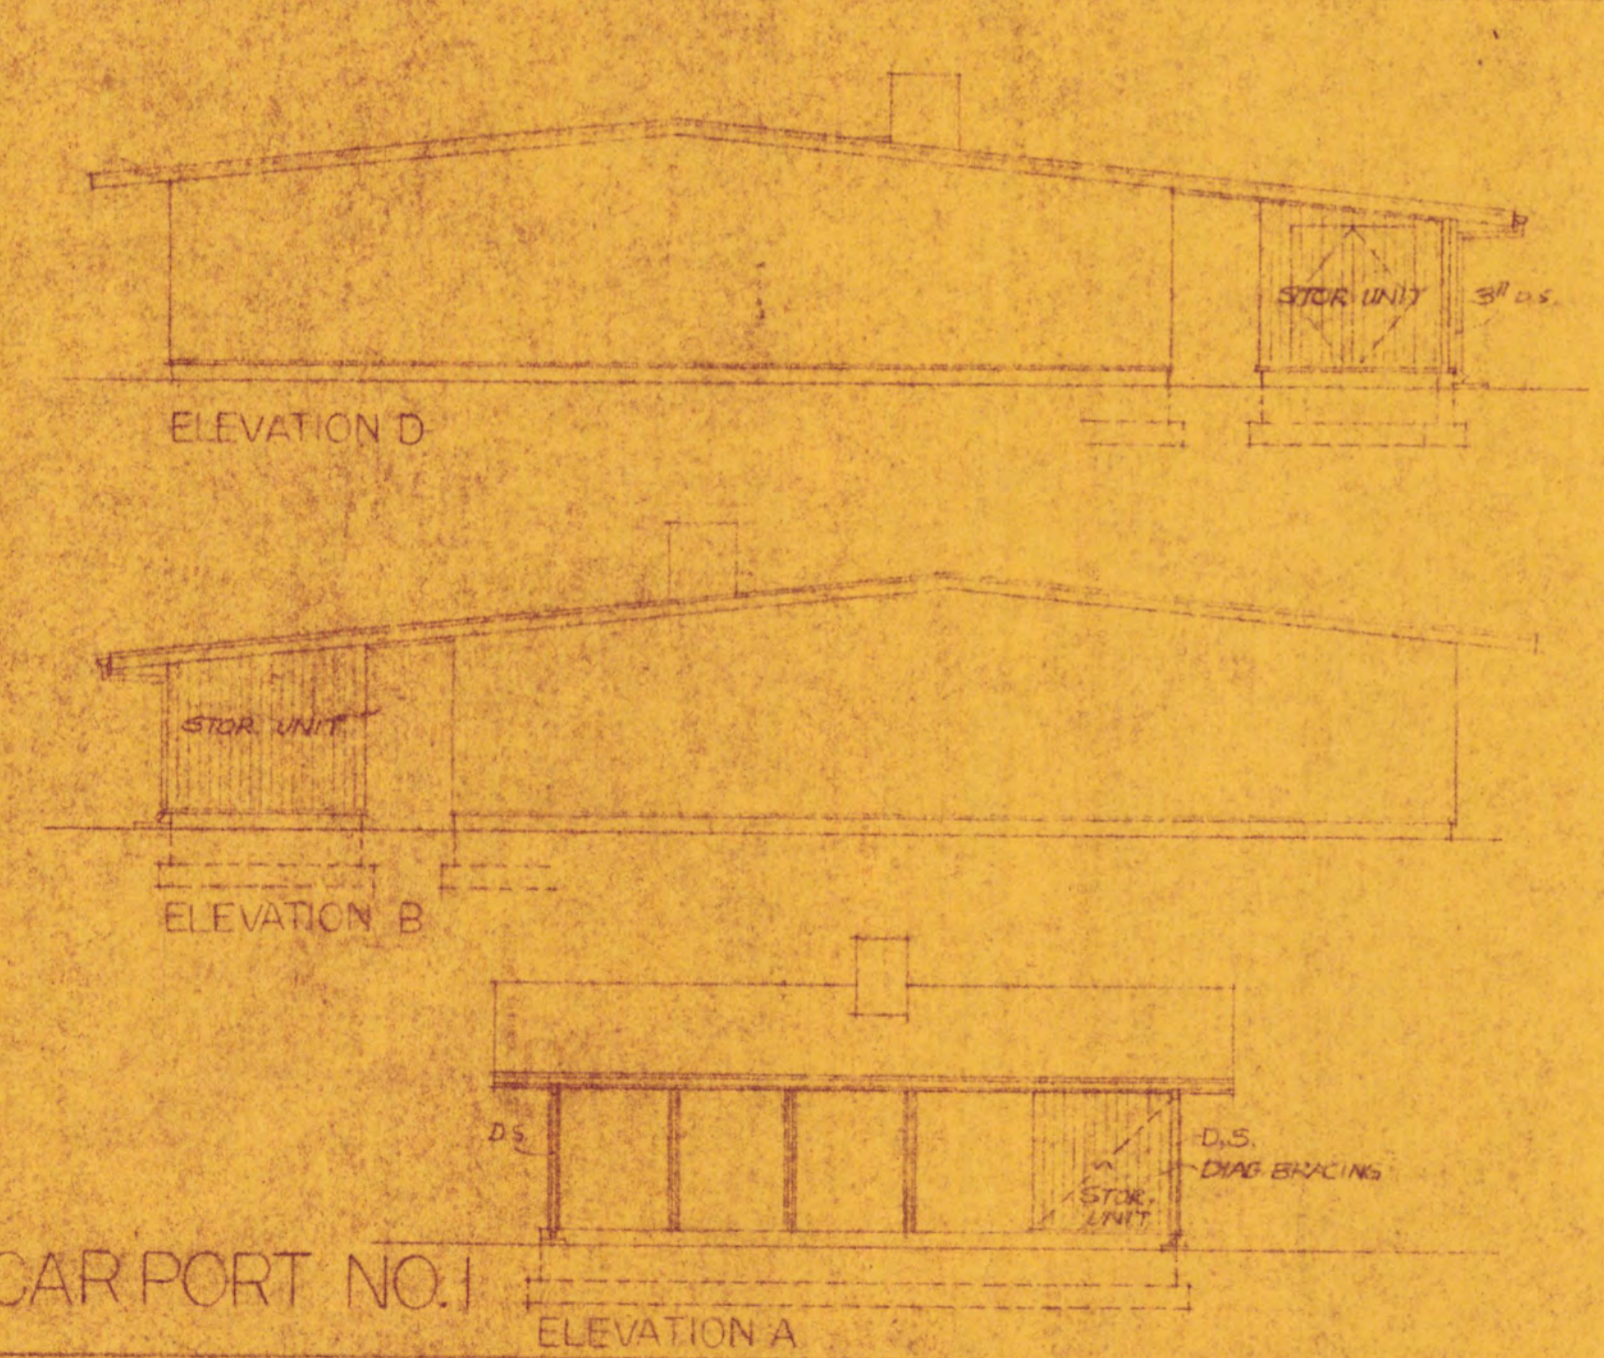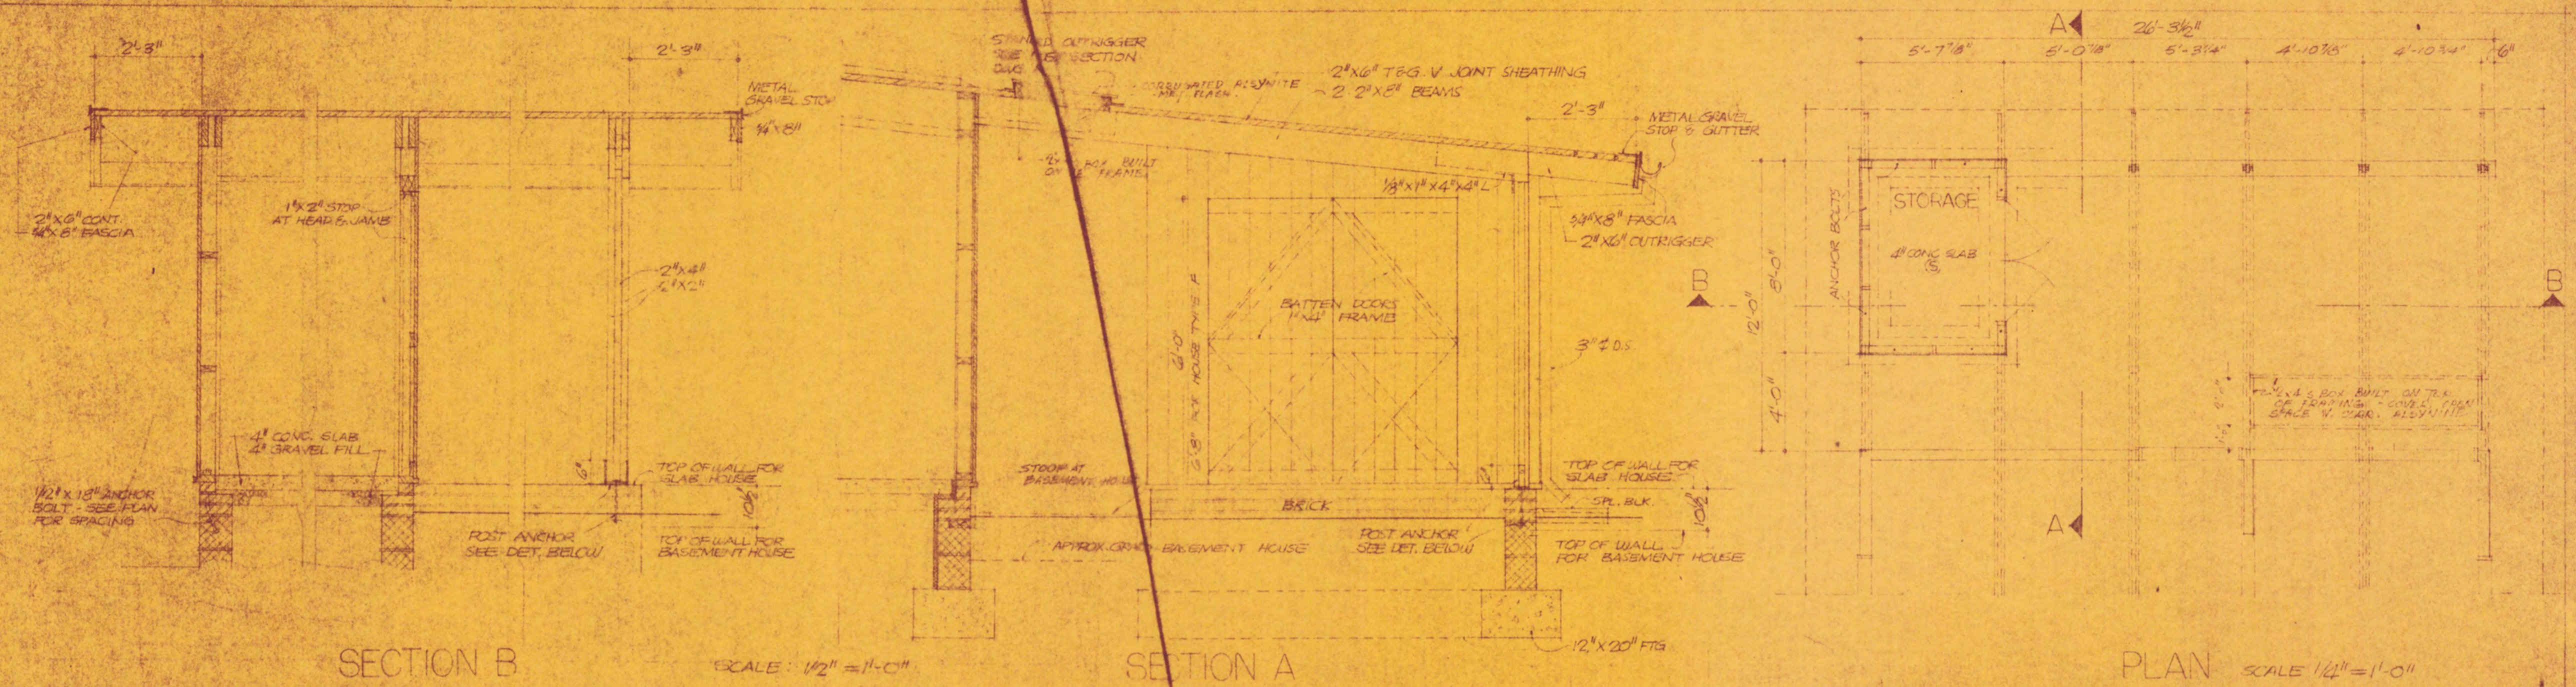


REVISIONS 6/3/52 - 2x6 CONTINUOUS 8/20/52 - ANCHOR BOLTS	PINE SPRING - LURIA BROS. BUILDERS LEE BLVD - LEE HIGHWAY, FAIRFAX COUNTY, VA. CARPORTS 1 & 2 FOR HSE TYPES B & F MAKE AS SHOWN 6/18/52	52-02 CP-1
KEYES, SMITH & BATTERLEE - ARCHT. ENGRS. FRANCIS D. LETHBRIDGE - ASSOCIATE THREE DUPONT CIRCLE - WASHINGTON 6, D.C. - ROBERT 3315		


36

INTERIOR FINISH SCHEDULE						
SPACE	FLOOR	WALLS		CEILING		REMARKS
	MATERIAL FINISH	MATERIAL	FINISH	MATERIAL	FINISH	
LIVING ROOM	BRN. TLR. CONC.	PAVING	BRN. WALL	BRN. PLANK	STAINED OR PAINTED	ACRN. TLR. GROUP C. DOORS & TRIM PAINTED AT WALL
DINING ROOM	"	"	"	"	"	"
KITCHEN	"	"	"	"	"	"
BATH	"	"	SET	REPAIRS	"	LIN. WALL - BRN. GLASS PLINT. CLASSIC TUB 6'-9" HIGH AT TUB
HALL	"	"	BRN. WALL	PAINTED	"	ACRN. TLR. GROUP C. DOORS & TRIM PAINTED AT WALL
BED ROOMS	"	"	"	"	"	"


DOOR SCHEDULE					
SYMBOL	TYPE	SIZE	NO. REQD.	FINISH	REMARKS
1	FL. S. C.	21'6" x 21'6"	1	PAINTED	ALL PLUSH DOORS PAINT GRASS
2	GL. PAN	18" SEE ELEV.	2	"	SEA. ELEV. THIS SHEET
3	H. N. C.	20'0" x 21'6"	3	"	"
4	FL. H. C.	20'0" x 21'6"	2	"	"
5	LOUVER	20'0" x 21'6"	1	"	SLIDING
6	FL. H. C.	20'0" x 21'6"	1	"	"
1s	SCREEN	21'6" x 21'6"	1	"	SEE ELEV. THIS SHEET
2s	"	18" SEE ELEV.	2	"	"

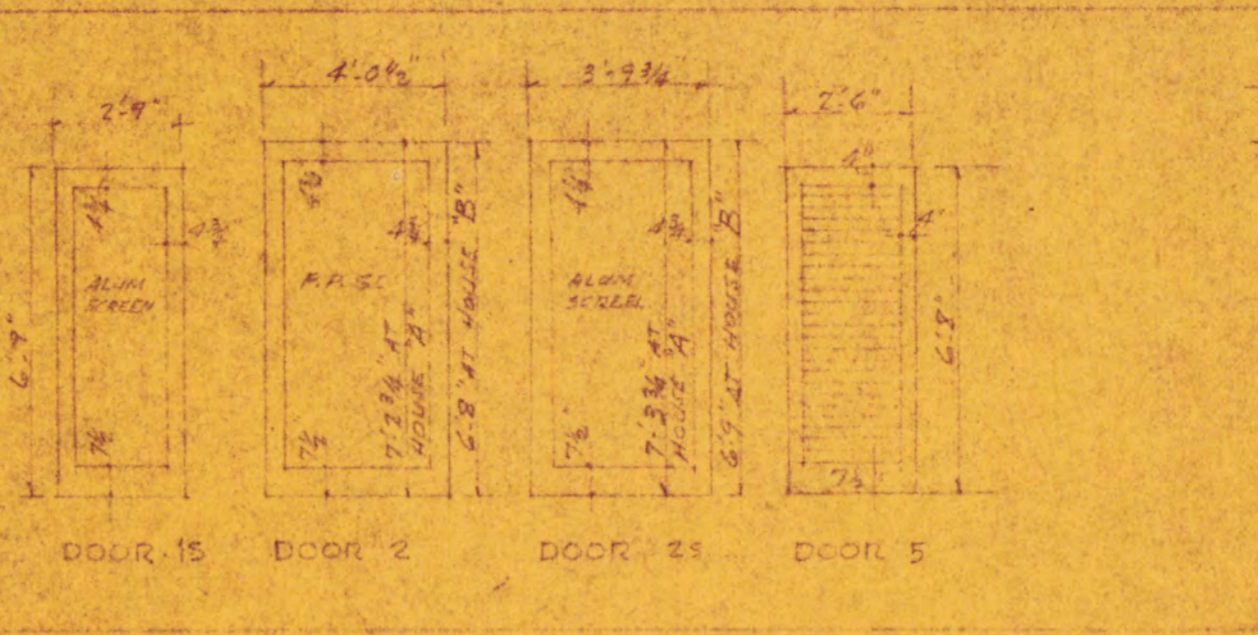

WINDOW SCHEDULE			
TYPE	SIZE	NO. REQD.	REMARKS
A	3'0" x 7'0"	2	ALUMINITE SLIDING ALUM. SASH 2 LIGHTS P.S.S. GL. REGN. SCREEN (FRAMES)
B	3'0" x 5'0"	3	"
C	3'0" x 5'0"	4	"

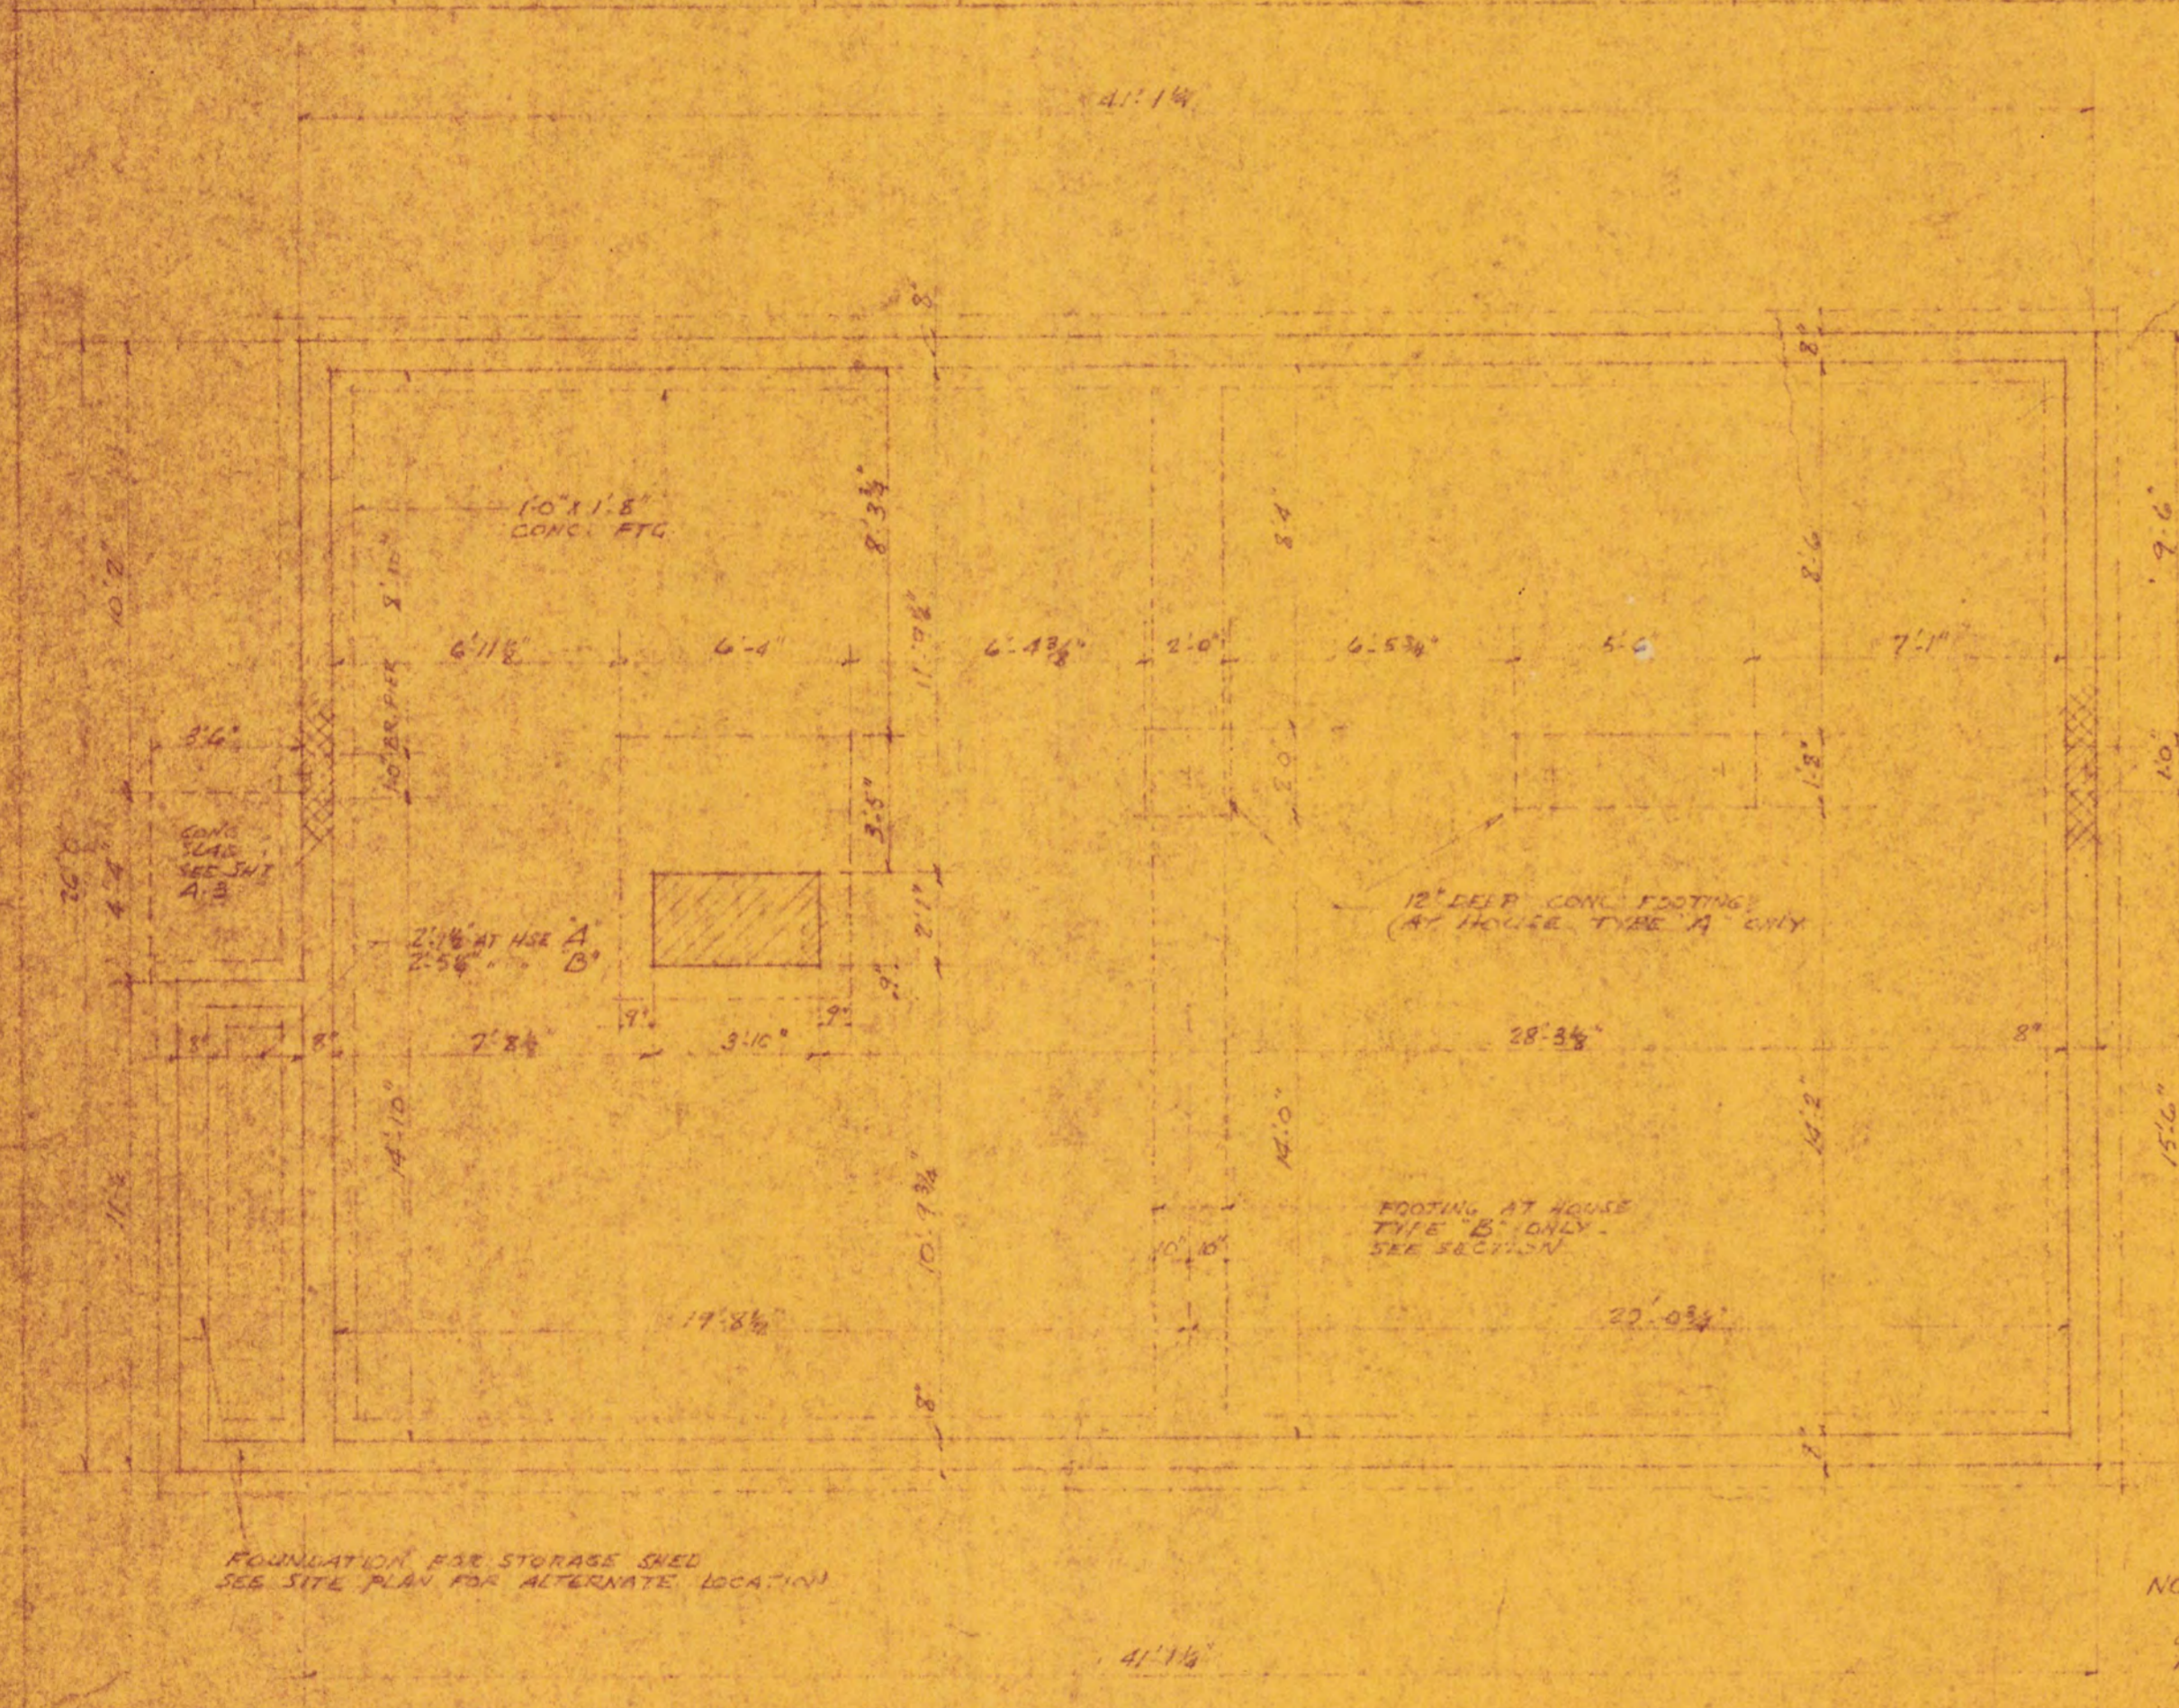

FOUNDATION PLAN

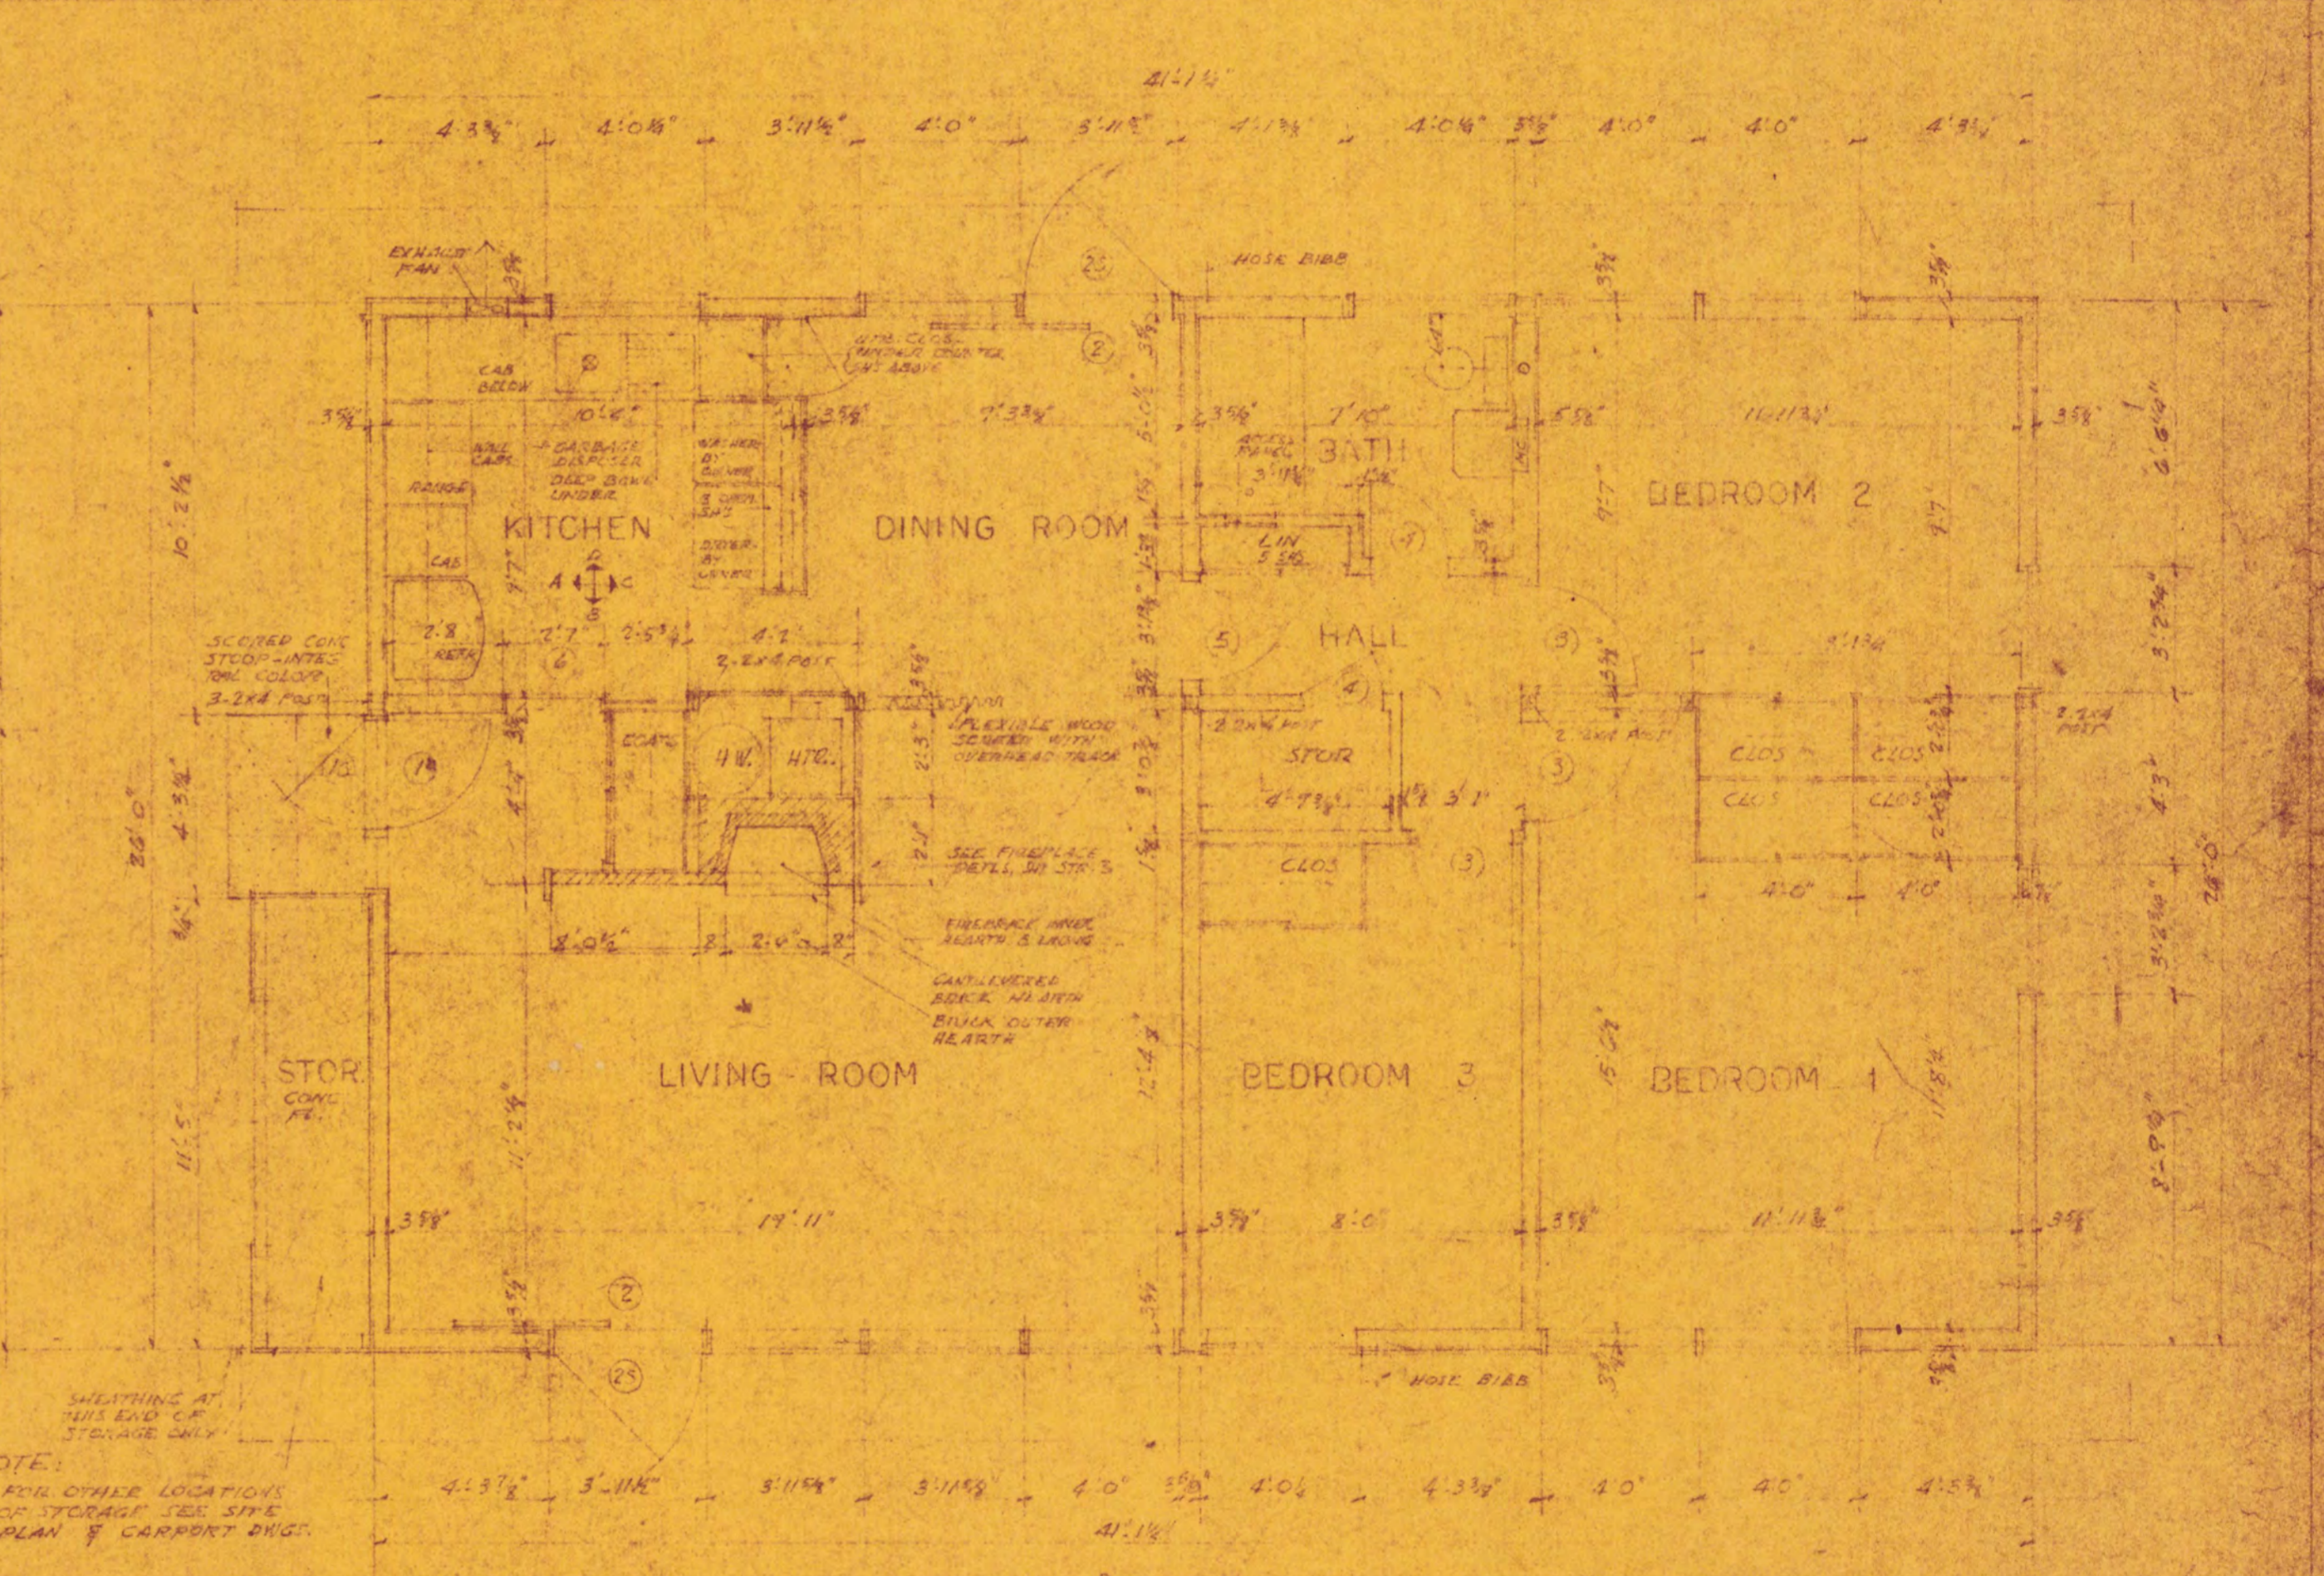

FLOOR PLAN

NOTE:
FOR OTHER LOCATIONS OF STORAGE SEE SITE PLAN & CARRIAGE DRG.

KEY TO INTERIOR ELEVATIONS
TYPES A & B

REVISIONS
10/9/52 HEARTH ADDED (F.H.A.) BRICK PANEL ADJACENT TO FIREPLACE ADDED

PINE SPRING - LURIA BROS. BUILDERS
LEE BLVD. - LEE HIGHWAY - FAIRFAX COUNTY, VA

FOUNDATION & FLOOR PLAN

SCALE 1/8" = 1'-0" DATE 4/13/52 DRAWN BY M.G. CHECKED BY

KEYES, SMITH & SATTERLEE ARCHT. ENGRS.
FRANCIS D. LEE, PRINCIPAL ASSOCIATE
THREE DUPONT CIRCLE WASHINGTON 6, D. C. HOBART 9815 OF

52-02
AB-1